


HOT WATER SUPPLY ROUTING SKETCH
LOWER LEVEL PLAN
 SCALE: 1/8" = 1'-0"

Ref Dwg: 108813-M101-&Demo-0Bsmt.dwg
**LESSNER 1ST FLR ADDITION &
 1ST FLR & LOWER LEVEL
 REHABILITATION**
 12 West Jersey Street
 Elizabeth, NJ 07202

Oct. 24, 2016
 Project # 108813.00

SK-035a

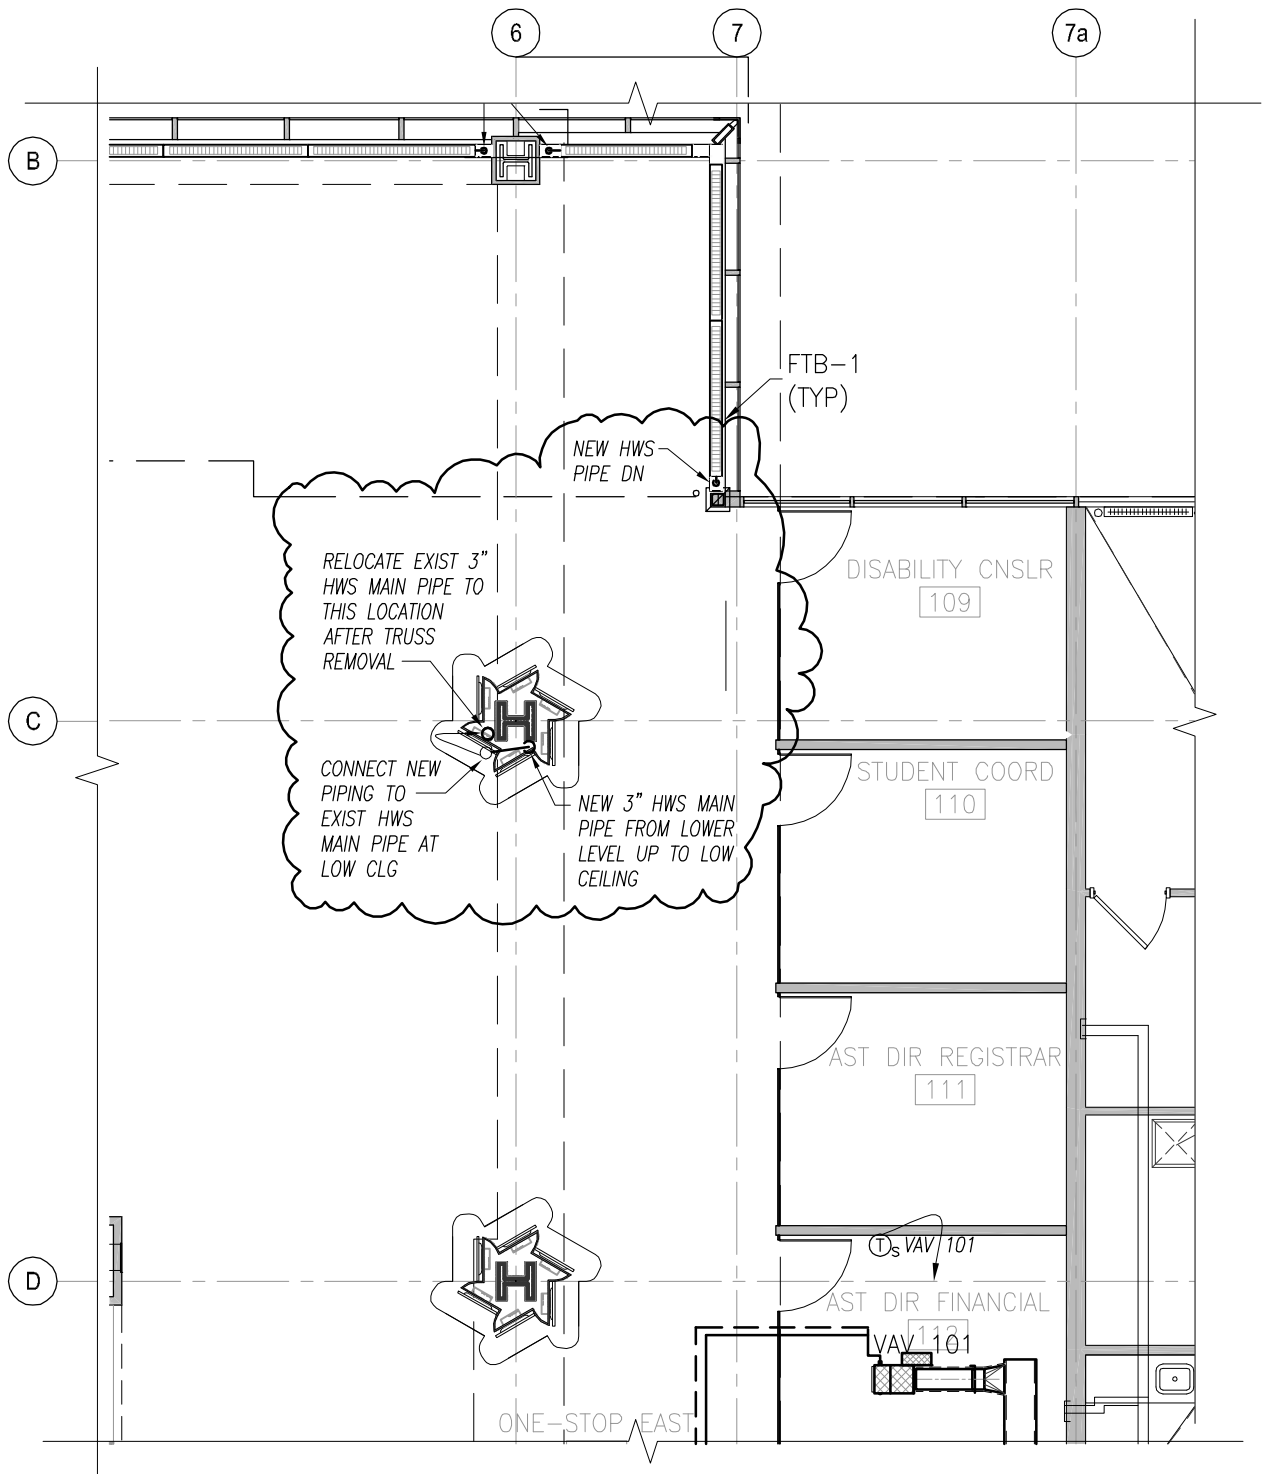

HOT WATER SUPPLY ROUTING SKETCH

FIRST FLOOR PLAN

SCALE: 1/8" = 1'-0"


Ref Dwg: 108813-M102-&Demo-1st.dwg

**LESSNER 1ST FLR ADDITION &
1ST FLR & LOWER LEVEL
REHABILITATION**

12 West Jersey Street
Elizabeth, NJ 07202

Oct. 24, 2016
Project # 108813.00

SK-035b

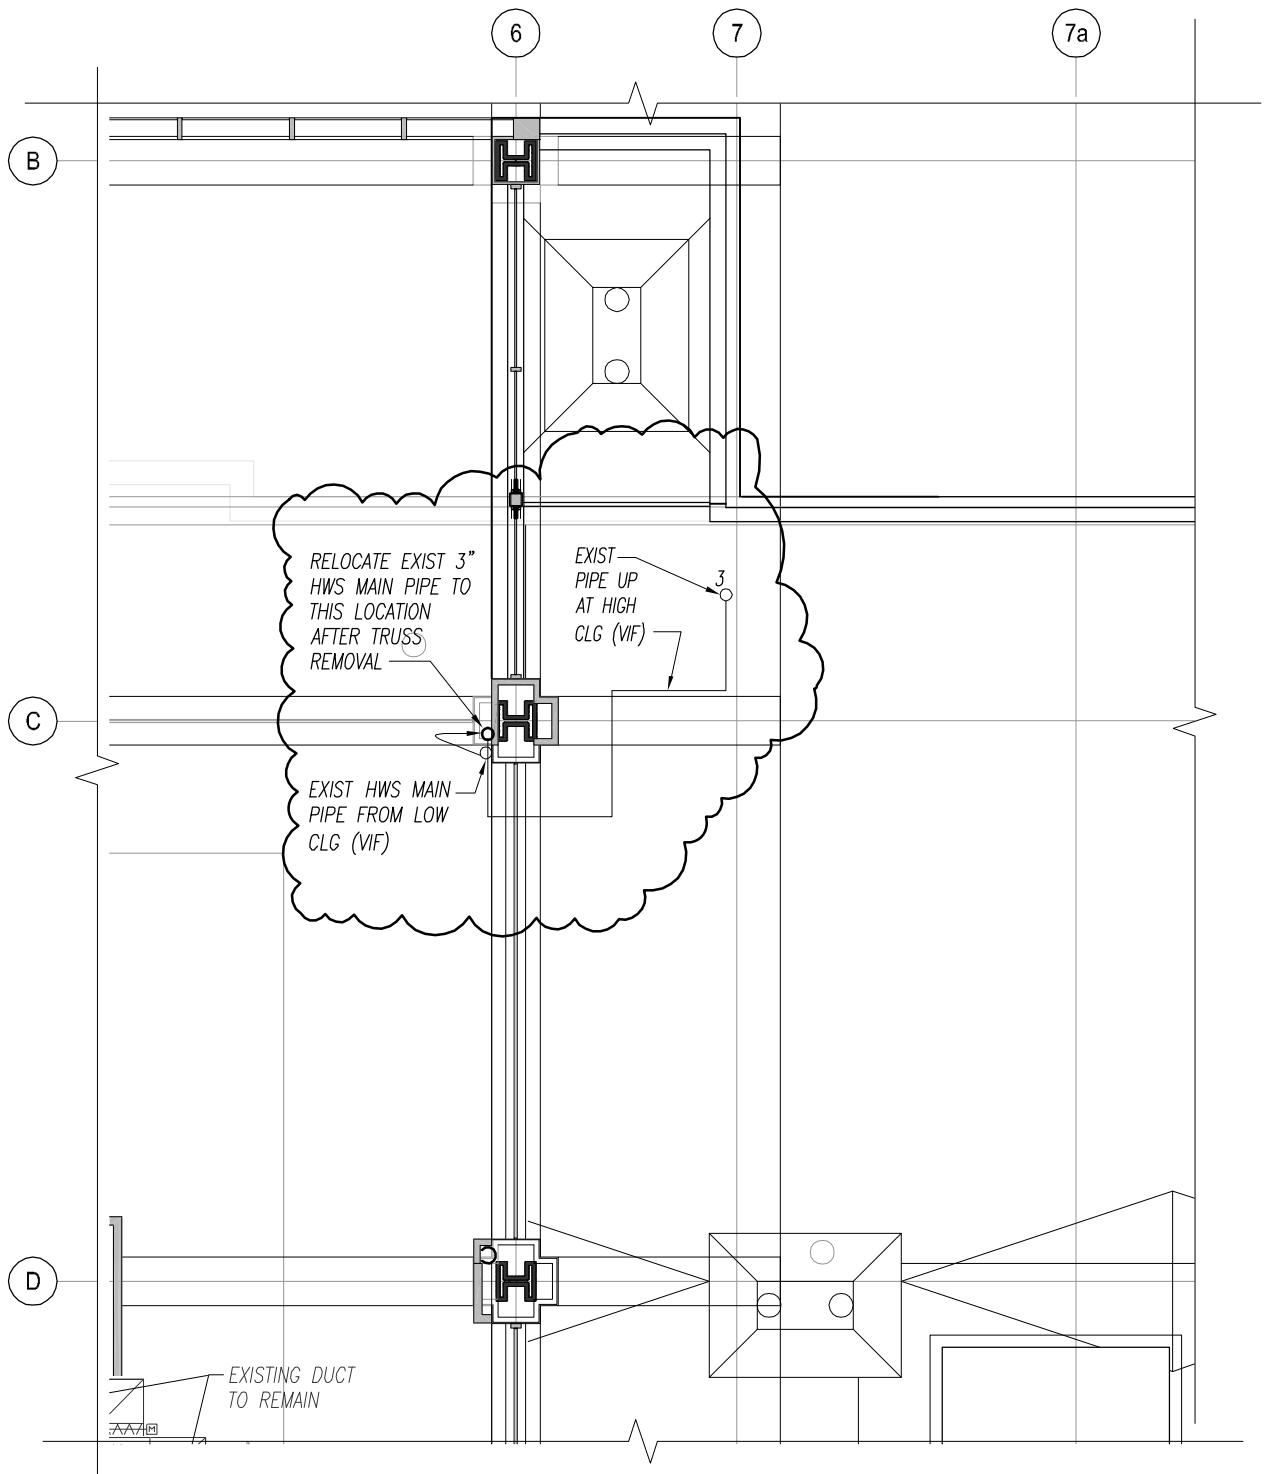

HOT WATER SUPPLY ROUTING SKETCH

LOW ROOF PLAN

SCALE: 1/8" = 1'-0"

Ref Dwg: 108813-M103--&Demo-2Roof.dwg

**LESSNER 1ST FLR ADDITION &
1ST FLR & LOWER LEVEL
REHABILITATION**

12 West Jersey Street
Elizabeth, NJ 07202

Oct. 24, 2016
Project # 108813.00

SK-035c

191 Mill Lane Mountainside, NJ 07092 p. 908.232.2860 f. 908.232.2845