

GENERAL NOTES

1. PROVIDE UL LISTED FIRE STOPPING AT ALL PIPING PENETRATION THROUGH CORRIDOR WALLS.

Eng. No.	24027837500
Arch. No.	21AC00912400
Date	01/15/2018
Checked	
Drawn	

KENNETH H. KARLE, R.A.
REGISTERED ARCHITECT
License No. NJ21A0089600


Revisions:

LAN ASSOCIATES
 engineering • planning • architecture • surveying
 445 GODWIN AVENUE, MIDLAND PARK, N.J. 07432 (201)447-6400


HVAC 1ST & 2ND FLR PIPING PLANS
 ADDITION TO WOODBRIDGE MIDDLE SCHOOL
 WOODBRIDGE BOE
 525 BARRON AVENUE
 WOODBRIDGE, NJ 07095

Job No. 2.20211.07
 File No. -


H2.04

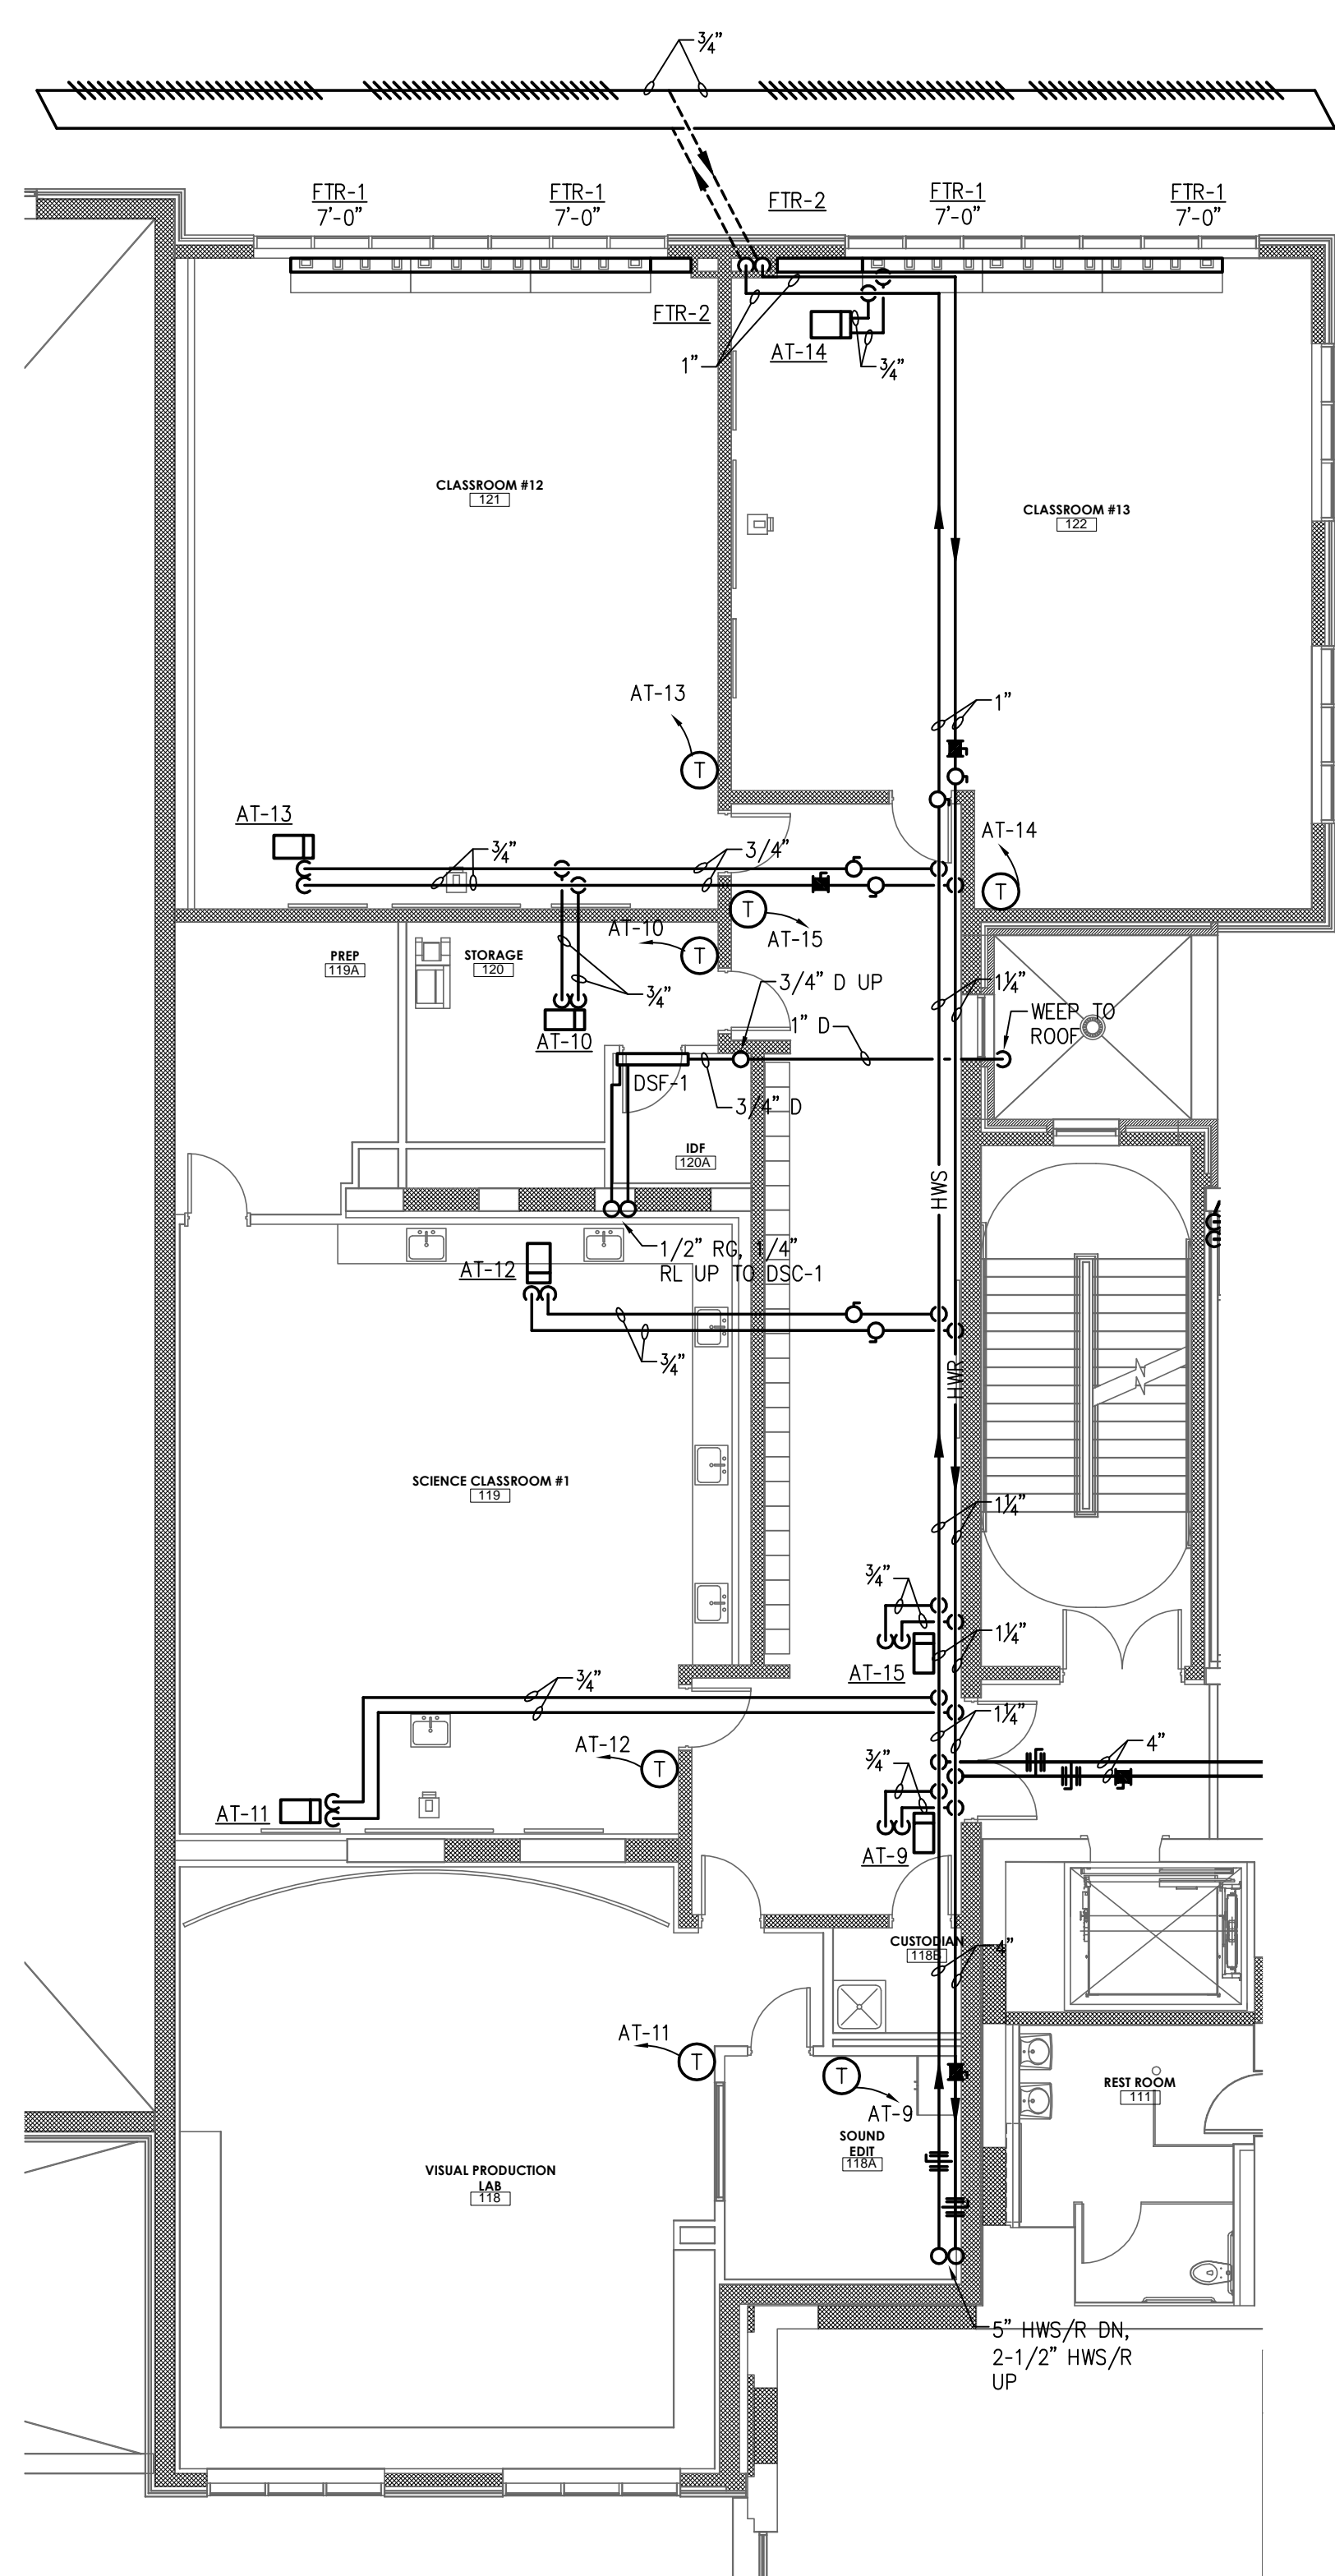

1 HVAC FIRST FLOOR PIPING PLAN
 H2.04 1/8" = 1'-0"

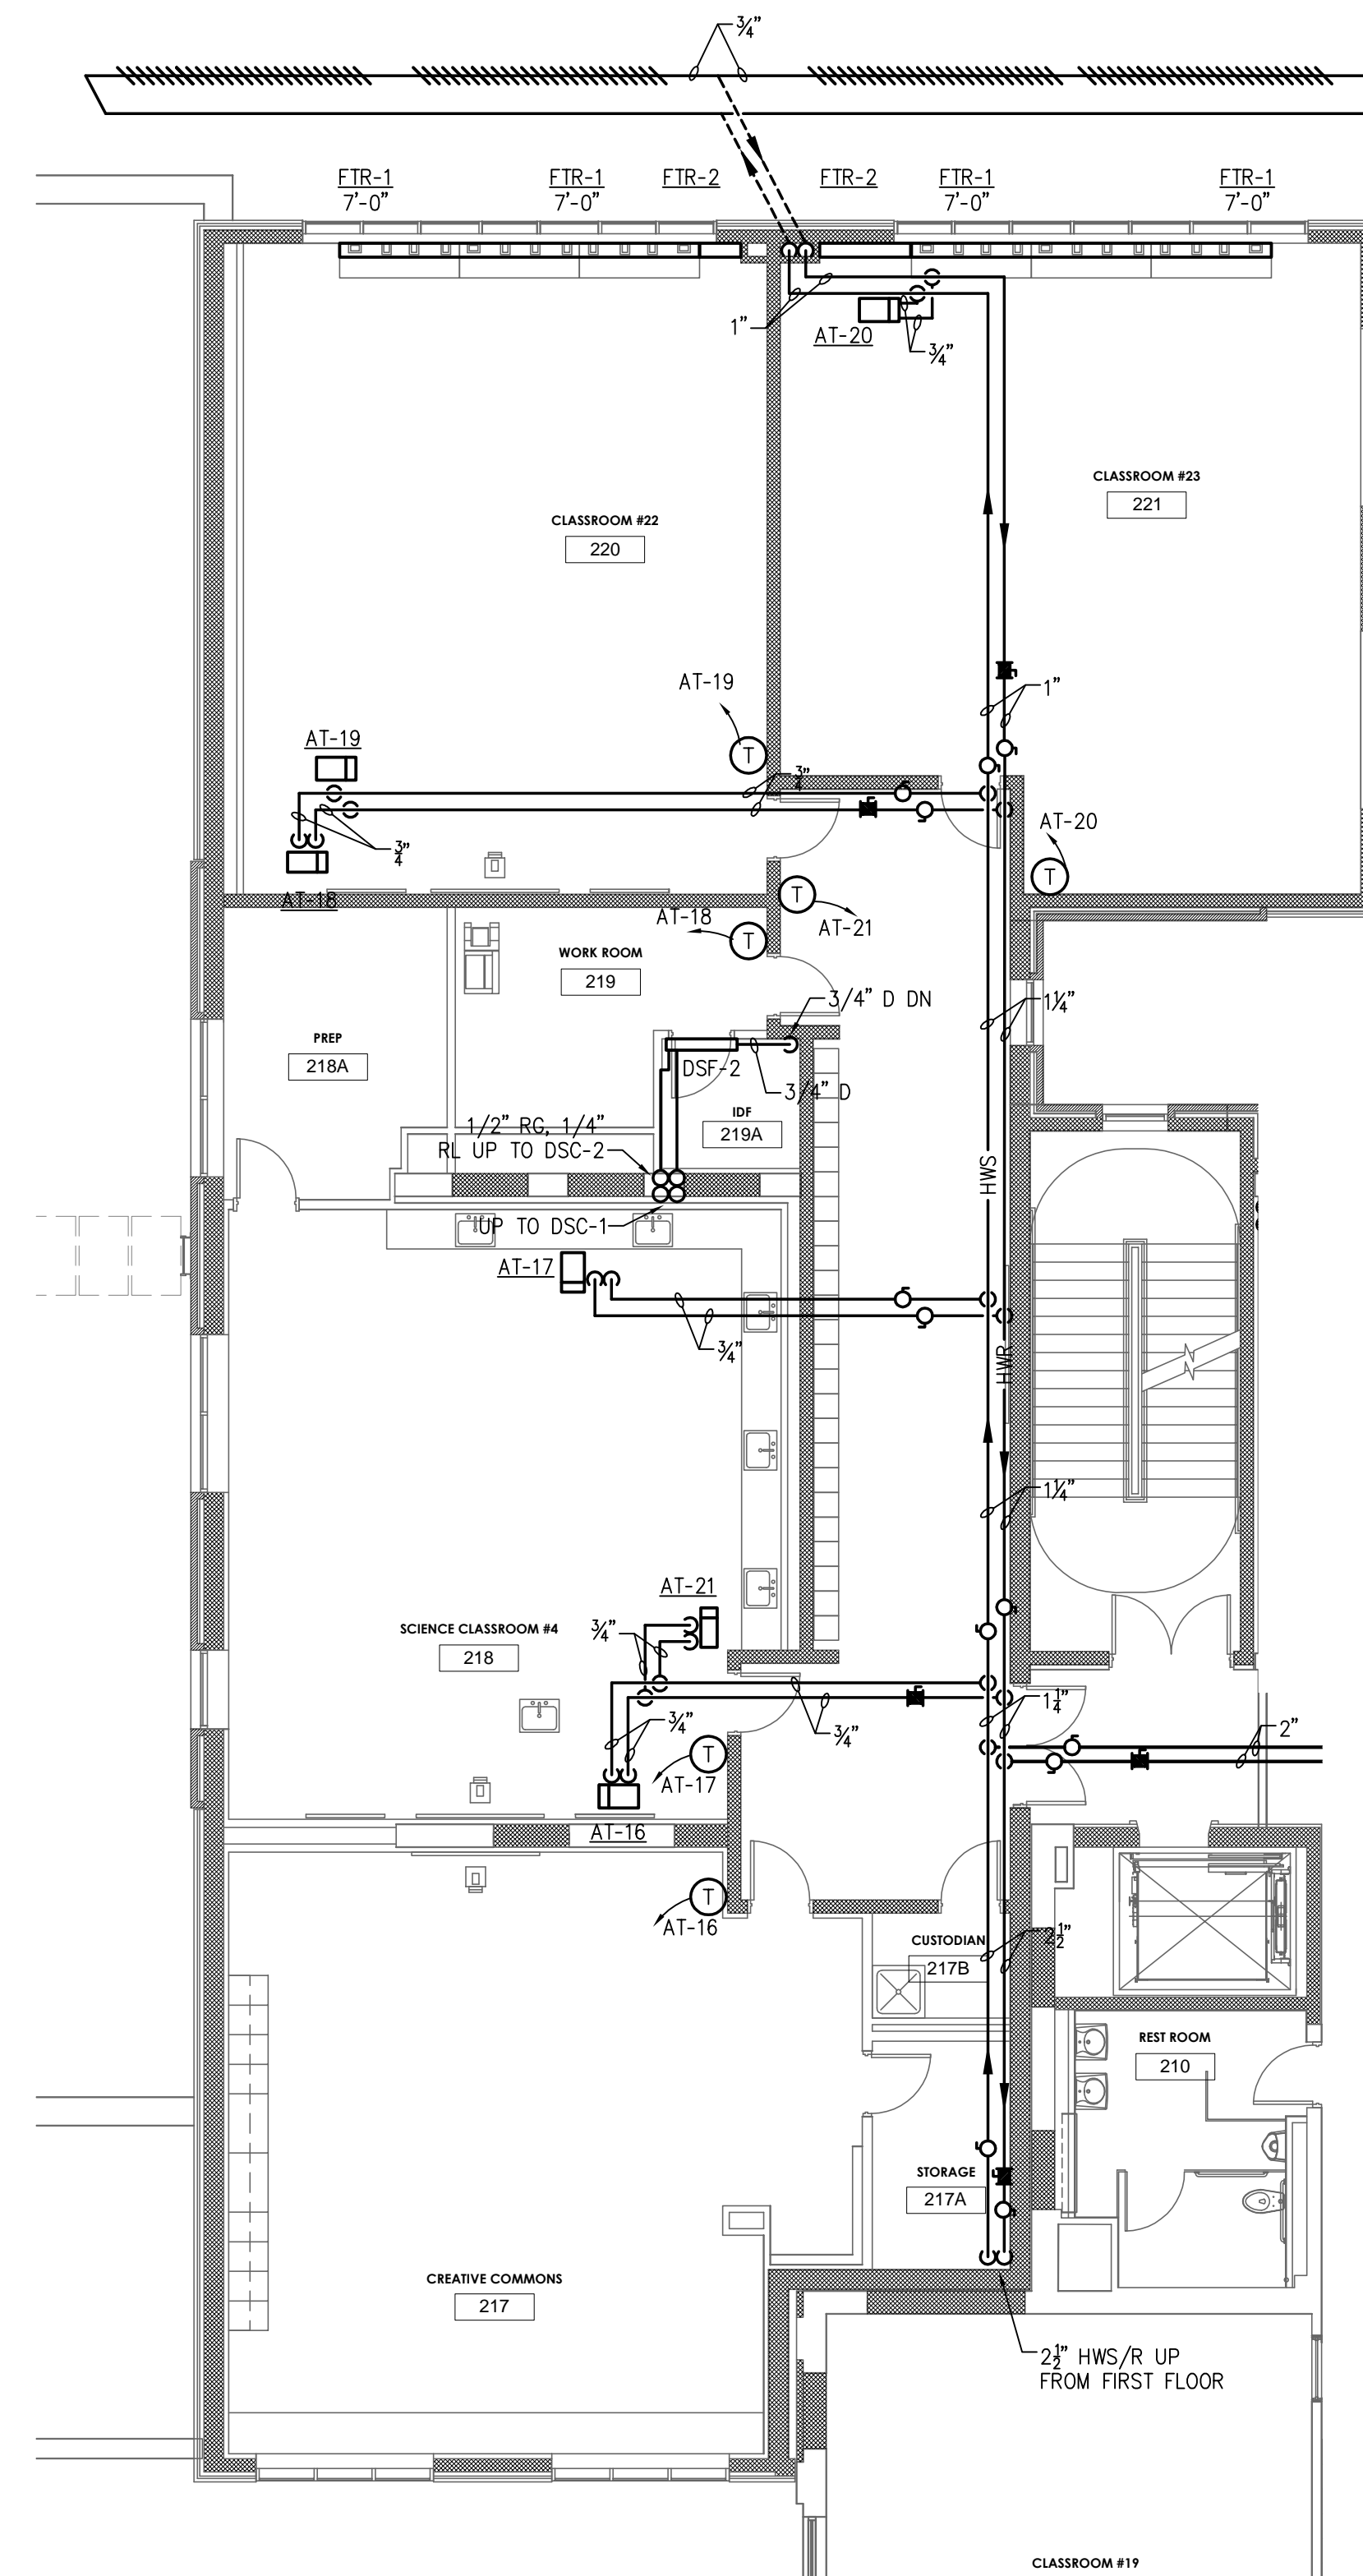

2 HVAC SECOND FLOOR PIPING PLAN
 H2.04 1/8" = 1'-0"

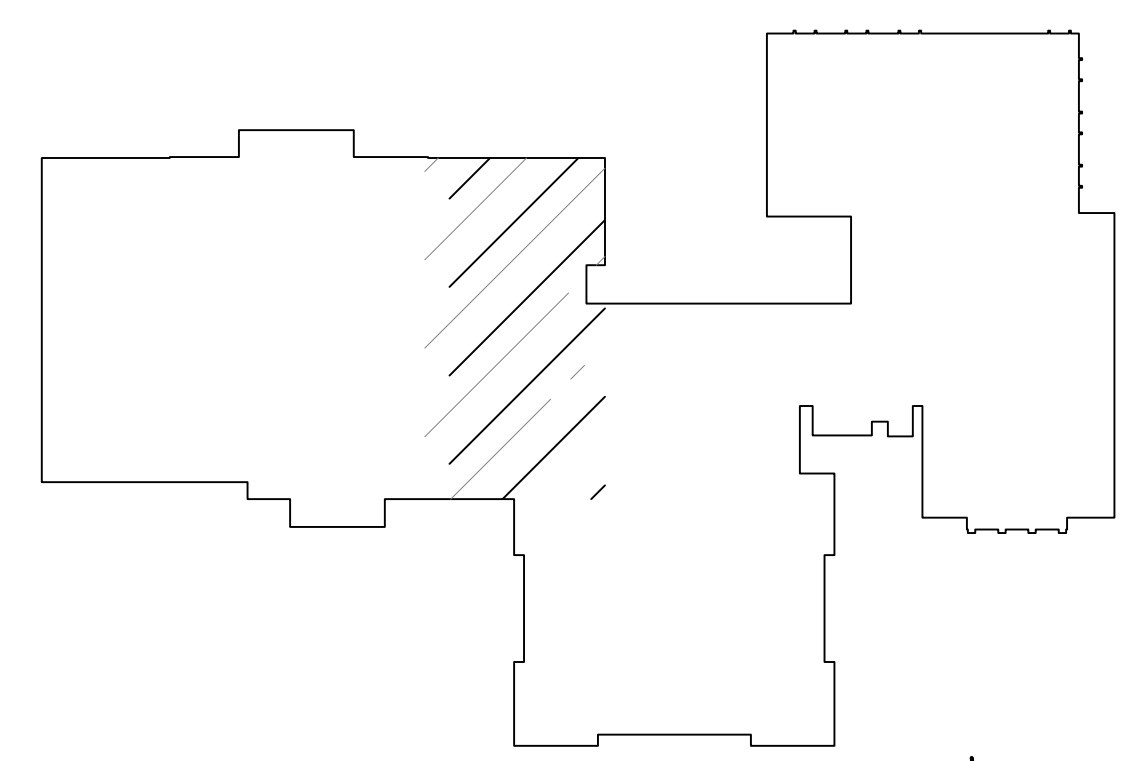

KEY PLAN
 N.T.S.