

FP-101 Part Lower Level Sprinkler Layout

Scale: 1/8" = 1'-0"

OCT 07, 2016
Project # 108813.00

Dwg Ref: 108813-FP101.dwg


UCC LESSNER BUILDING - ELIZABETH CAMPUS
FIRST FLOOR & LOWER LEVEL RENOVATION

12 West Jersey Street
Elizabeth, NJ 07202

SK-19a

THE MUSIAL GROUP ARCHITECTURE

191 Mill Lane Mountainside, NJ 07092 p. 908.232.2860 f. 908.232.2845

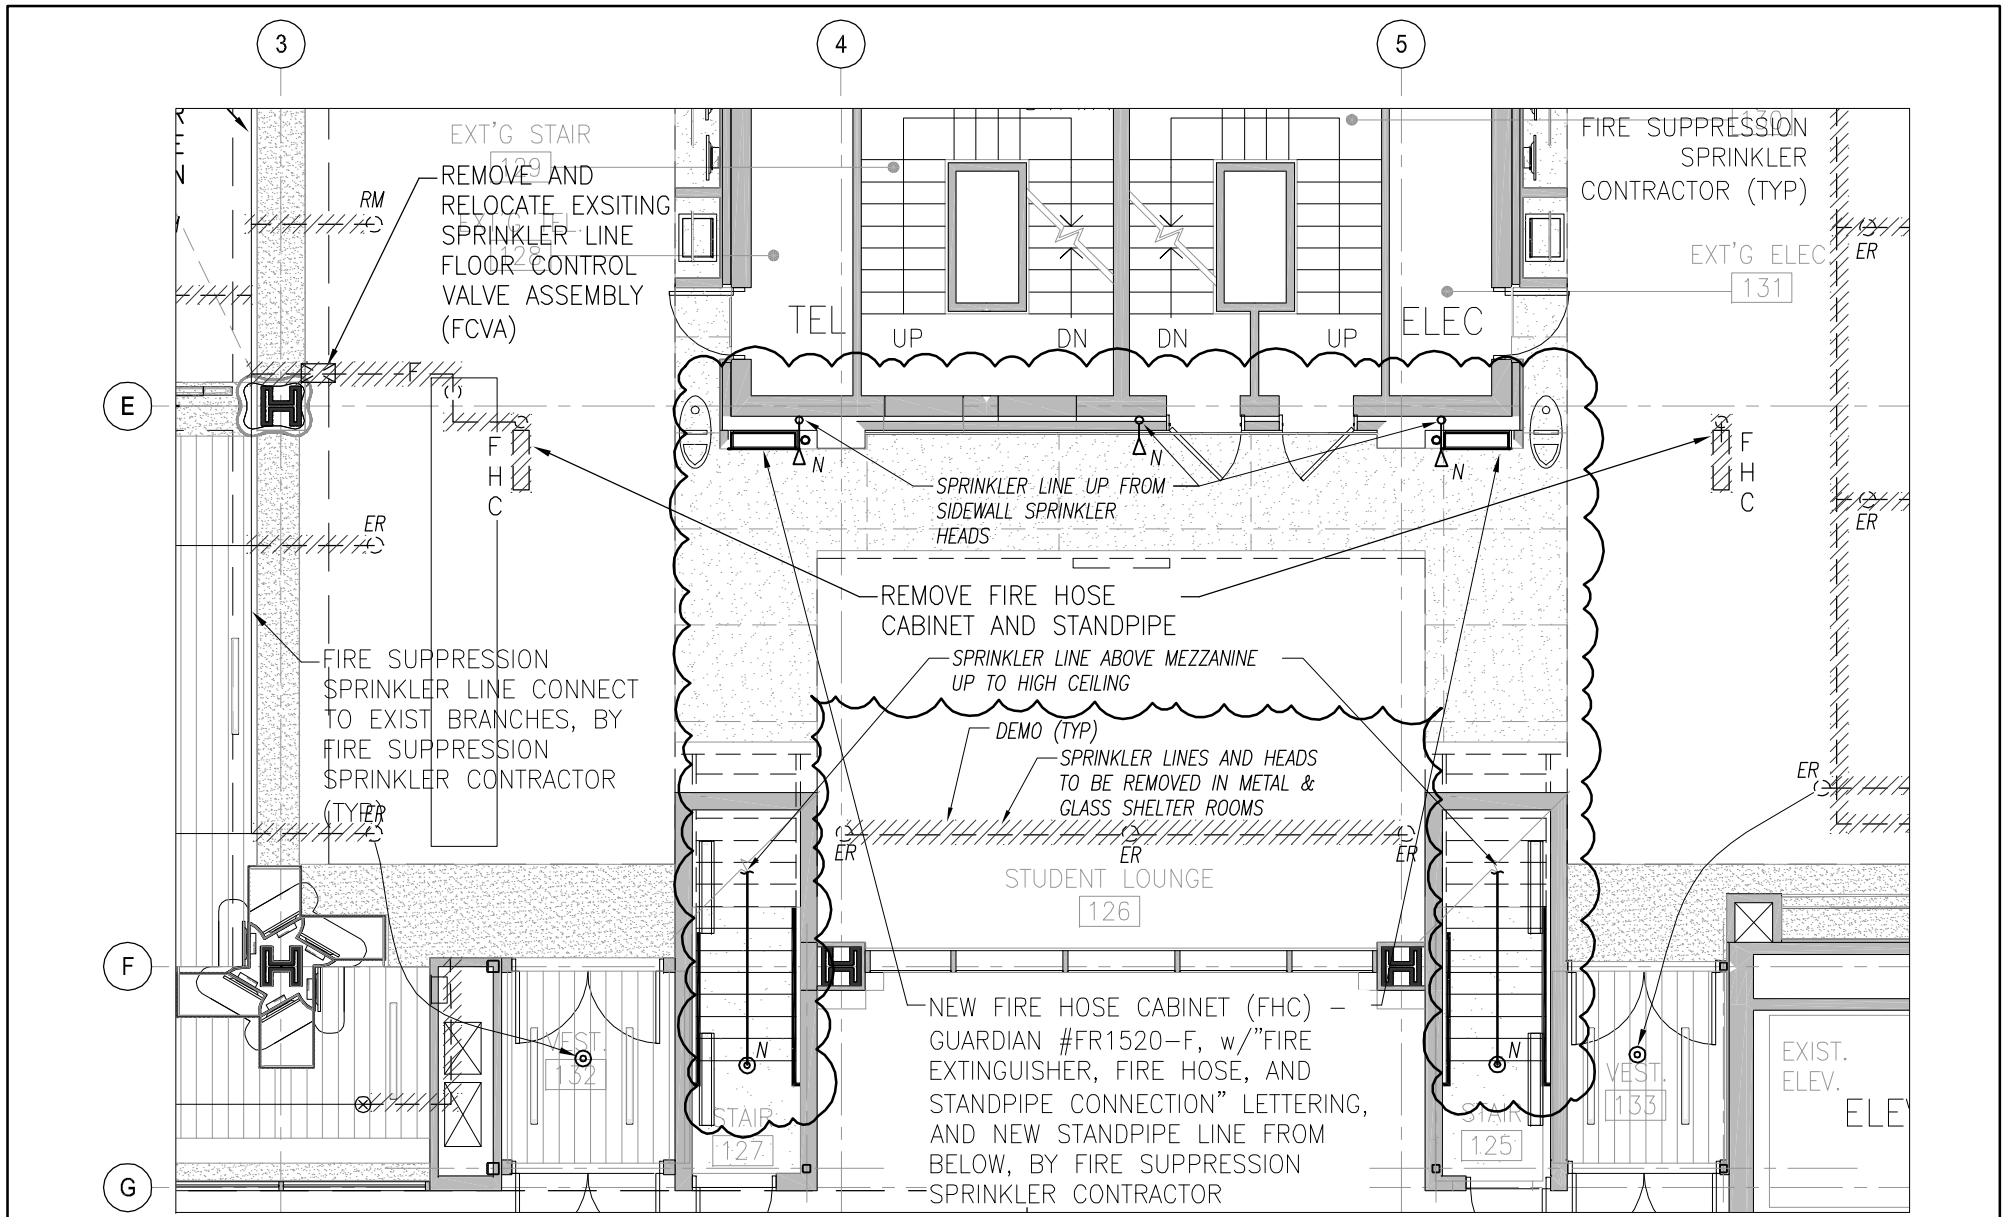


FP-102 Part First Floor Low Level
Sprinkler Layout

Scale: 1/8" = 1'-0"

OCT 07, 2016
 Project # 108813.00

Dwg Ref: 108813-FP102.dwg
UCC LESSNER BUILDING - ELIZABETH CAMPUS
FIRST FLOOR & LOWER LEVEL RENOVATION
 12 West Jersey Street
 Elizabeth, NJ 07202

SK-19b
THE MUSIAL GROUP ARCHITECTURE
 191 Mill Lane Mountainside, NJ 07092 p. 908.232.2860 f. 908.232.2845

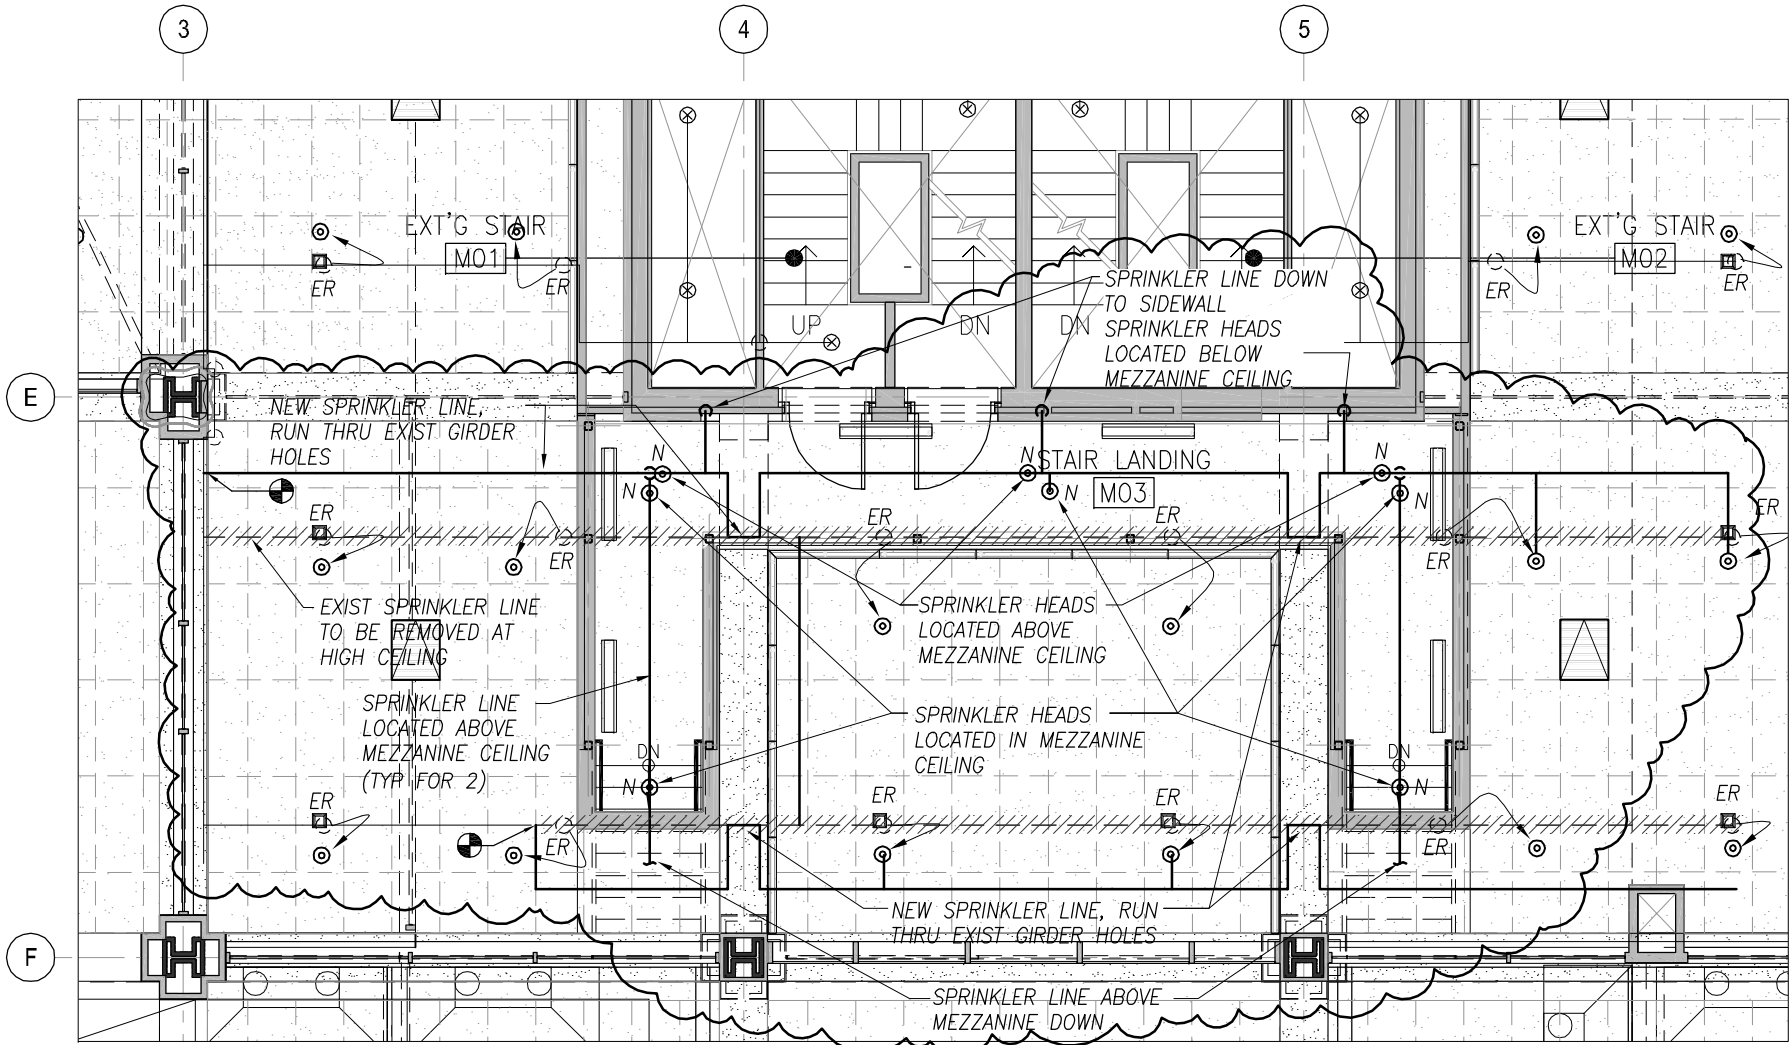

FP-103 Part First Floor Upper Level Sprinkler
 Mezzanine Layout

Scale: 1/8" = 1'-0"

OCT 07, 2016
 Project # 108813.00

Dwg Ref: 108813-FP103.dwg


UCC LESSNER BUILDING - ELIZABETH CAMPUS
FIRST FLOOR & LOWER LEVEL RENOVATION

12 West Jersey Street
 Elizabeth, NJ 07202

SK-19c

THE MUSIAL GROUP ARCHITECTURE

191 Mill Lane Mountainside, NJ 07092 p. 908.232.2860 f. 908.232.2845

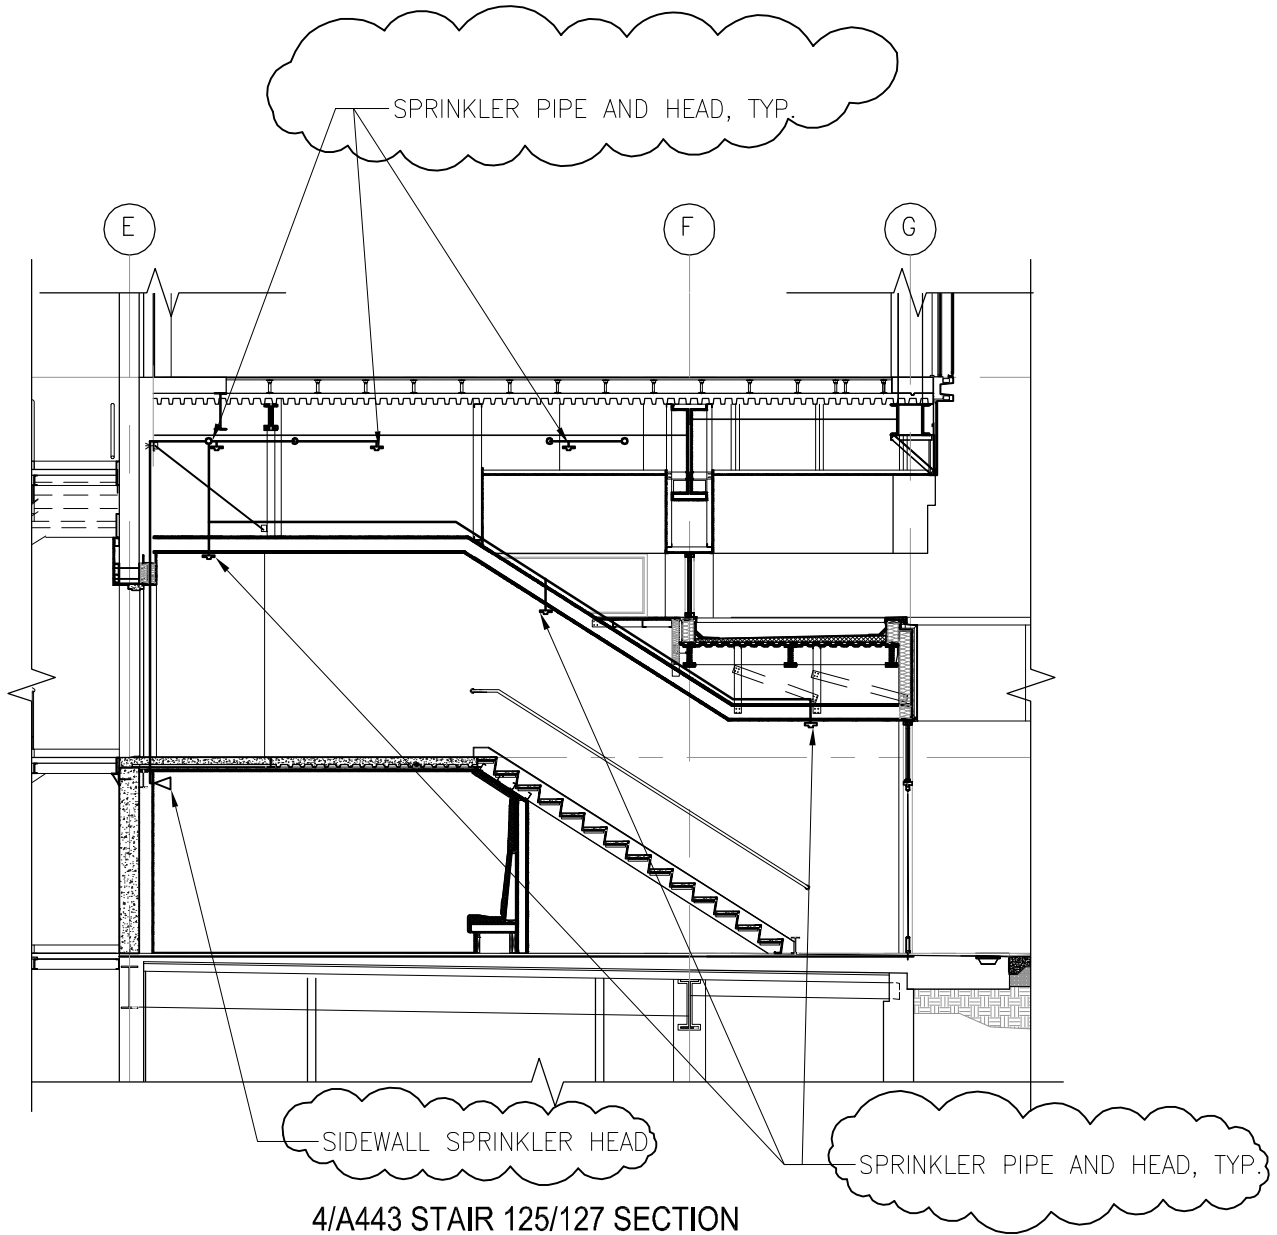

4/A443 STAIR 125/127 SECTION
SPRINKLER LOCATIONS

SCALE: 1/8" = 1'-0"

**LESSNER 1ST FLR ADDITION &
1ST FLR & LOWER LEVEL
REHABILITATION**

12 West Jersey Street
Elizabeth, NJ 07202

SK-19e

Project # 108813.00
2016-10-07