


- GENERAL NOTES
1. REFER TO DRAWING ED.1 FOR SYMBOLS AND ABBREVIATIONS.
 2. REFER TO DRAWING ED.2 FOR GENERAL NOTES.
 3. REFER TO DRAWING E1.11 FOR GENERAL DEMOLITION NOTES.
 4. REFER TO MECHANICAL AND PLUMBING DEMOLITION DRAWINGS FOR ALL EQUIPMENT AND ASSOCIATED BRANCH CIRCUIT CONDUIT AND WIRING REQUIRED TO BE DEMOLISHED THAT MAY OR MAY NOT BE INDICATED ON THESE DRAWINGS.
 5. ALL WORK ASSOCIATED WITH THE CORRIDOR AND STAIRWELL LIGHTING RENOVATIONS SHALL BE PROVIDED AS AN ALTERNATE.

- DEMOLITION KEY NOTES
- 1 THE ENTIRETY OF THE EXISTING FIRE ALARM SYSTEM INCLUDING CONTROL PANELS, REMOTE ANNUNCIATORS, DEVICES, CONDUIT, WIRING, ETC. SHALL BE DISCONNECTED AND REMOVED. NOTE THIS WORK SHALL NOT HAPPEN UNTIL THE NEW FIRE ALARM SYSTEM HAS BEEN INSTALLED, TESTED, AND APPROVED.
 - 2 UNLESS OTHERWISE NOTED, EXISTING LIGHTING FIXTURES SHALL BE DISMANTLED AND MODIFIED WITH NEW LED RETROFIT KITS. EXISTING BRANCH CIRCUIT CONDUIT AND WIRING SHALL REMAIN AND BE MODIFIED/EXTENDED AS REQUIRED FOR THE INSTALLATION OF THE NEW RETROFIT KITS. ASSOCIATED SWITCHING CONTROL SHALL BE DISCONNECTED AND REMOVED AS REQUIRED. FURNISH AND INSTALL NEW COVERPLATES FOR EXISTING BOXES TO REMAIN.
 - 3 EXISTING WALL PACK TO BE DISCONNECTED AND REMOVED. EXISTING BRANCH CIRCUIT CONDUIT AND WIRING SHALL REMAIN.
 - 4 EXISTING EXIT, EMERGENCY HEAD, AND COMBINATION EXIT/EMERGENCY HEAD FIXTURES SHALL BE DISCONNECTED AND REMOVED. EXISTING CONDUIT AND WIRING SHALL REMAIN.
 - 5 EXISTING LIGHTING FIXTURES ASSOCIATED CONTROL TO BE DISCONNECTED AND REMOVED. EXISTING BRANCH CIRCUIT CONDUIT AND WIRING TO REMAIN.
 - 6 THE EXISTING INTERCOM/CLOCK/PA SYSTEM TO BE REMOVED AND REPLACED WITH A NEW BOGEN INTERCOM/CLOCK/PA SYSTEM. THE CONTRACTOR SHALL REMOVE ALL EXISTING SYSTEM COMPONENTS. EXISTING SYSTEM WIRING MAY BE RE-USED WHERE TESTED AND FOUND TO BE IN GOOD CONDITION.
 - 7 EXISTING PENDANT MOUNTED LINEAR FIXTURES AND ASSOCIATED SWITCHING SHALL BE DISCONNECTED AND REMOVED. EXISTING BRANCH CIRCUIT CONDUIT AND WIRING SHALL REMAIN.
 - 8 EXISTING UTILITY KW/KWHR DEMAND METER TO BE DISCONNECTED AND RELOCATED.
 - 9 EXISTING MAIN SERVICE DISTRIBUTION SWITCHBOARD TO BE REPLACED. REFER TO DRAWING E6.1 FOR MORE INFORMATION.

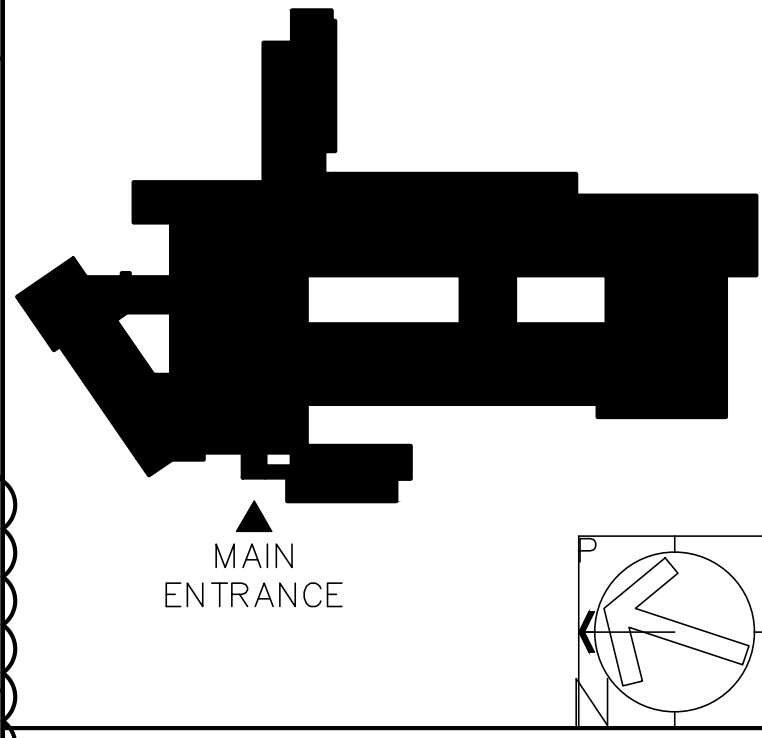

30 galesi drive
wayne, nj 07470
tel 973.256.0202 || fax 973.256.0227

MEMBERS OF THE AMERICAN INSTITUTE OF ARCHITECTS

GERMANO RUBINO, AIA NJ # AI 08084
JOSEPH DI CARA, AIA NJ # AI 08265

NOT VALID FOR BUILDING UNLESS SIGNED AND SEALED BY ARCHITECT

X Board President of Schools

X Superintendent of Schools



295 State Route 34
Colts Neck, NJ 07722
t 732.772.1500
f 732.772.1515

Mark E. Lonergan, P.E.
NJ License #24260407P000

J&U Project # 18-058

FACILITY UPGRADES AT:
BELLEVILLE HIGH SCHOOL

100 PASSAIC AVENUE
BELLEVILLE, NEW JERSEY 07109
BELLEVILLE PUBLIC SCHOOL DISTRICT,
BOARD OF EDUCATION

**ELECTRICAL
PARTIAL LOWER LEVEL
DEMOLITION**

SCALE AS NOTED

REV.	DATE:	DRN	CHK
	09/10/2018		ISSUED FOR BID
▲	10/02/2018		ADDENDUM #2

STATE PROJECT NO.
13-0250-020-17-1000

PROJECT NO. **3377** SHEET NO. **E1.14**

Plotted: 10/02/18 - 12:43 PM, By: jdonahue
 File: U:\Projects\18-058 Belleville Schools-High School_MEP\18-058E1.DEMO.dwg-E:1.14