




GANNETT FLEMING, P.C.
ENGINEERS AND ARCHITECTS

George R. Campanella
GEORGE R. CAMPANELLA
N.J. Professional Engineer # 24GE04252500

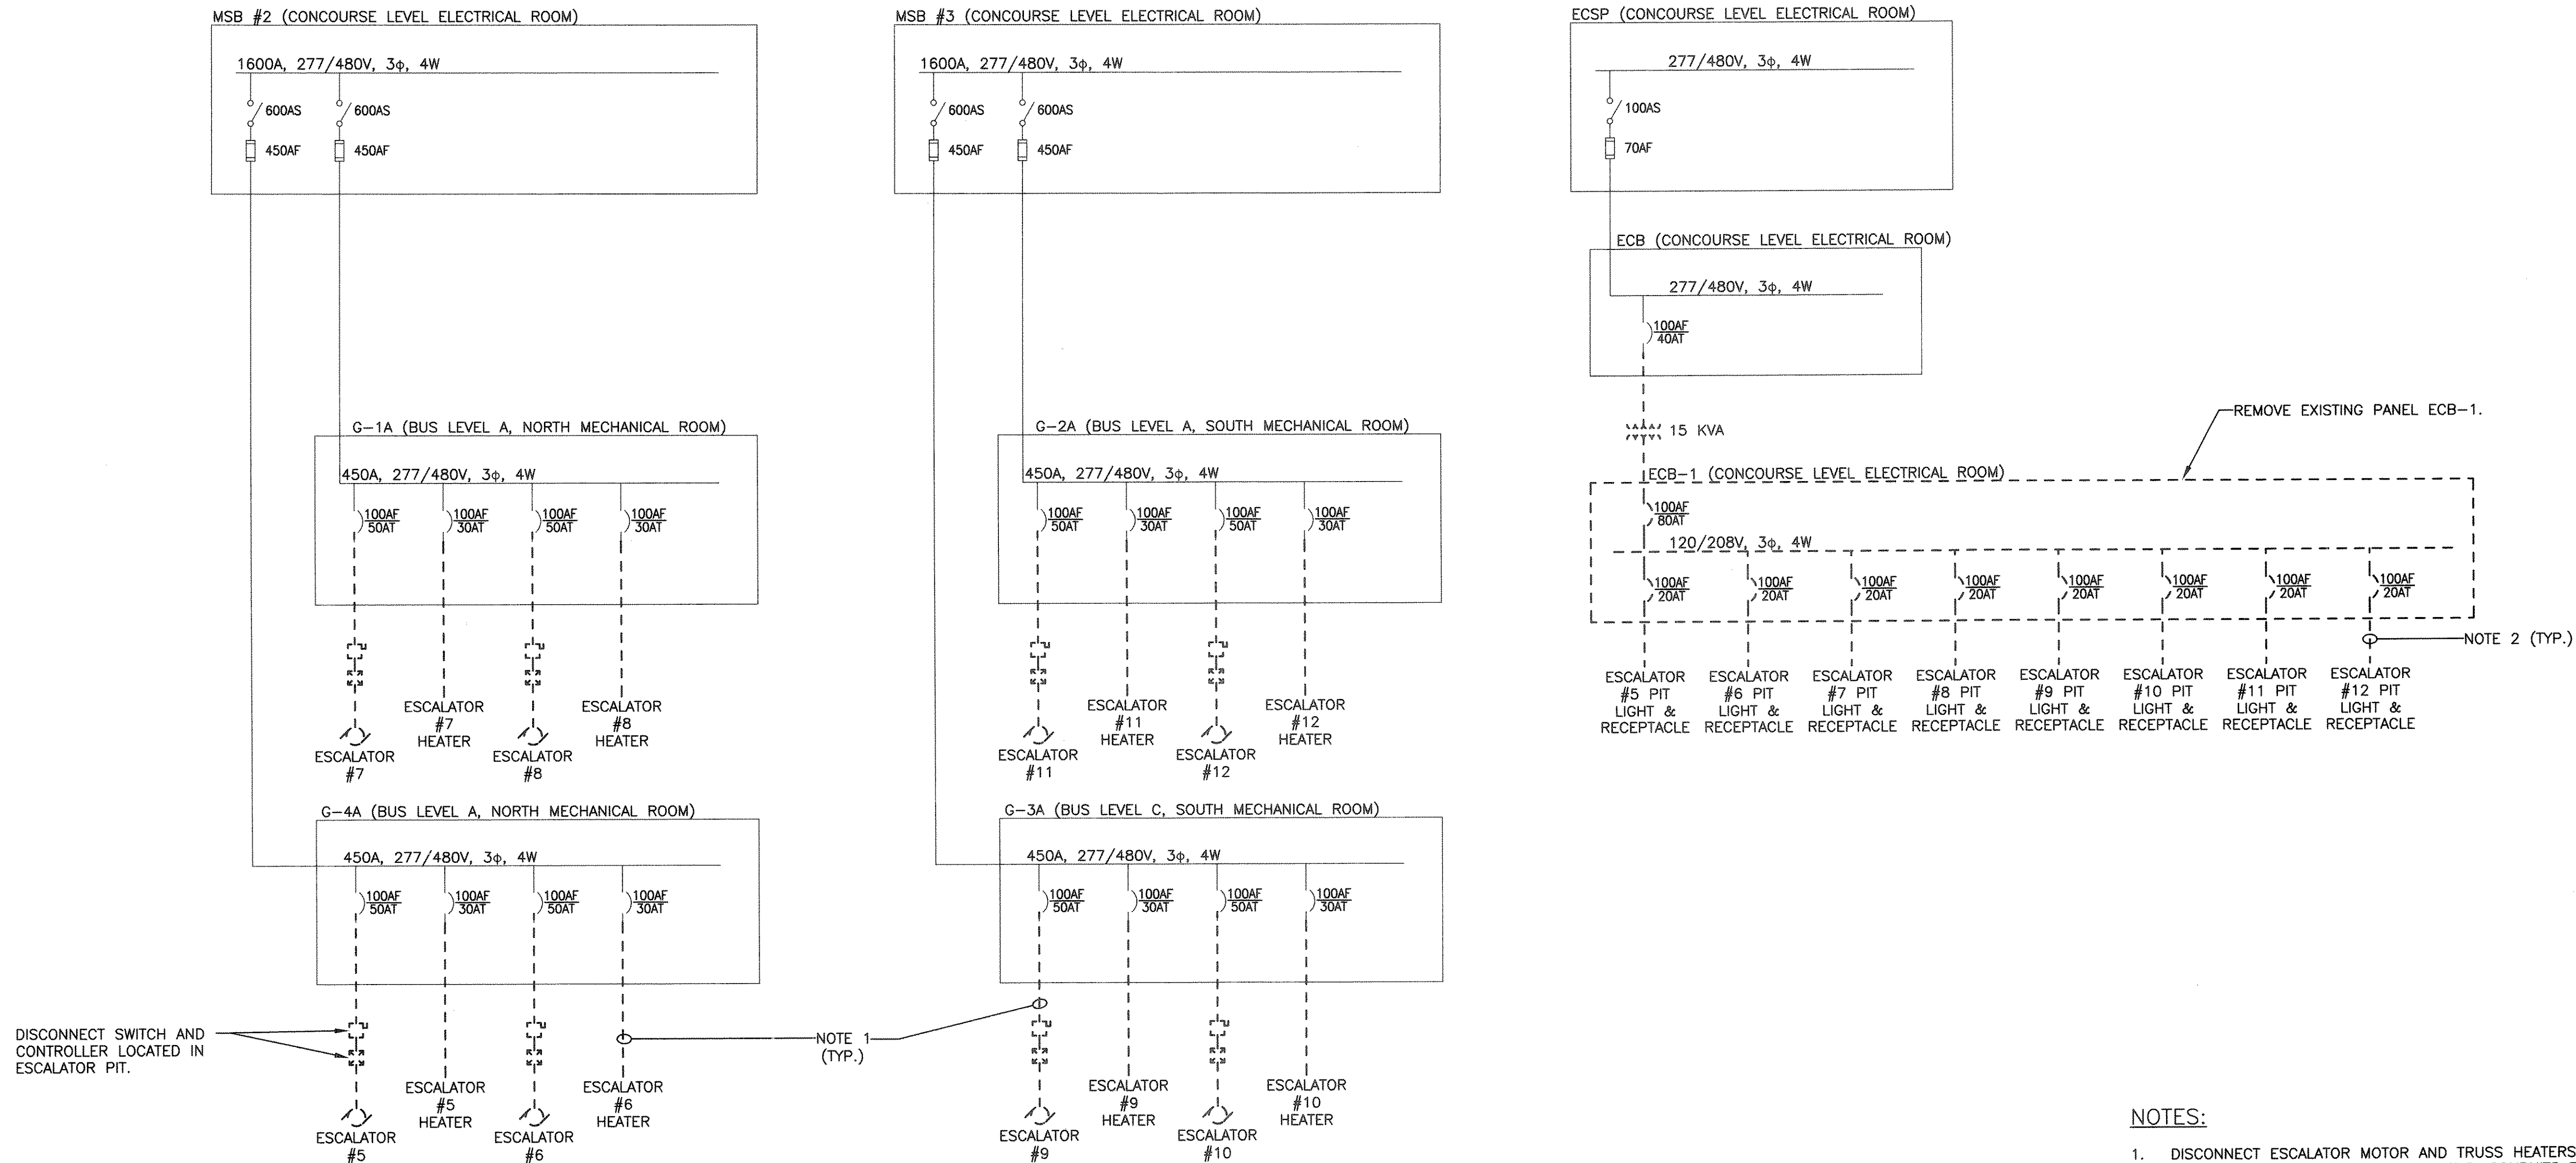

- NOTES:**
- DISCONNECT ESCALATOR MOTOR AND TRUSS HEATERS. REMOVE CONDUCTORS BACK TO PANELS. CONDUITS TO REMAIN FOR REUSE.
 - DISCONNECT ESCALATOR PIT LIGHTS AND RECEPTACLES. REMOVE CONDUCTORS BACK TO PANEL ECB-1. CONDUITS TO REMAIN FOR REUSE.
 - PANEL LOCATIONS ON CONTRACT DRAWING E005.
 - FOR LEGEND, ABBREVIATIONS, AND GENERAL NOTES SEE CONTRACT DRAWING E001.

D 1 POWER REMOVAL SINGLE LINE DIAGRAM
E008 SCALE: N.T.S.

No.	Date	Revision	Approved
ENGINEERING DEPARTMENT			
JOURNAL SQUARE TRANSPORTATION CENTER			

ELECTRICAL
Title
BUS TERMINAL ESCALATOR REPLACEMENT
POWER REMOVAL SINGLE LINE DIAGRAM

This drawing subject to conditions in contract. All inventions, ideas, designs and methods herein are reserved to Port Authority and may not be used without its written consent.
All recipients of Contract documents, including bidders and those who do not bid and their prospective subcontractors and suppliers who may receive all or a part of the Contract documents or copies thereof, shall make every effort to ensure the secure and appropriate disposal of the Contract documents to prevent further disclosure of the information contained in the documents. Secure and appropriate disposal includes methods of document destruction such as shredding or arrangements with refuse handlers that ensure that third persons will not have access to the documents' contents either before, during, or after disposal. Documents may also be returned for disposal purposes to the Contract office of the Director of Procurement, One Madison Avenue, 7th Floor, New York NY 10010.

T. GILLEN	A. CONCHADO	G. CAMPANELLA
Designed by	Drawn by	Checked by
Date	11/17/2008	
Contract Number	PAT-214.004	
Drawing Number	E009	
	PID# 07957000	