

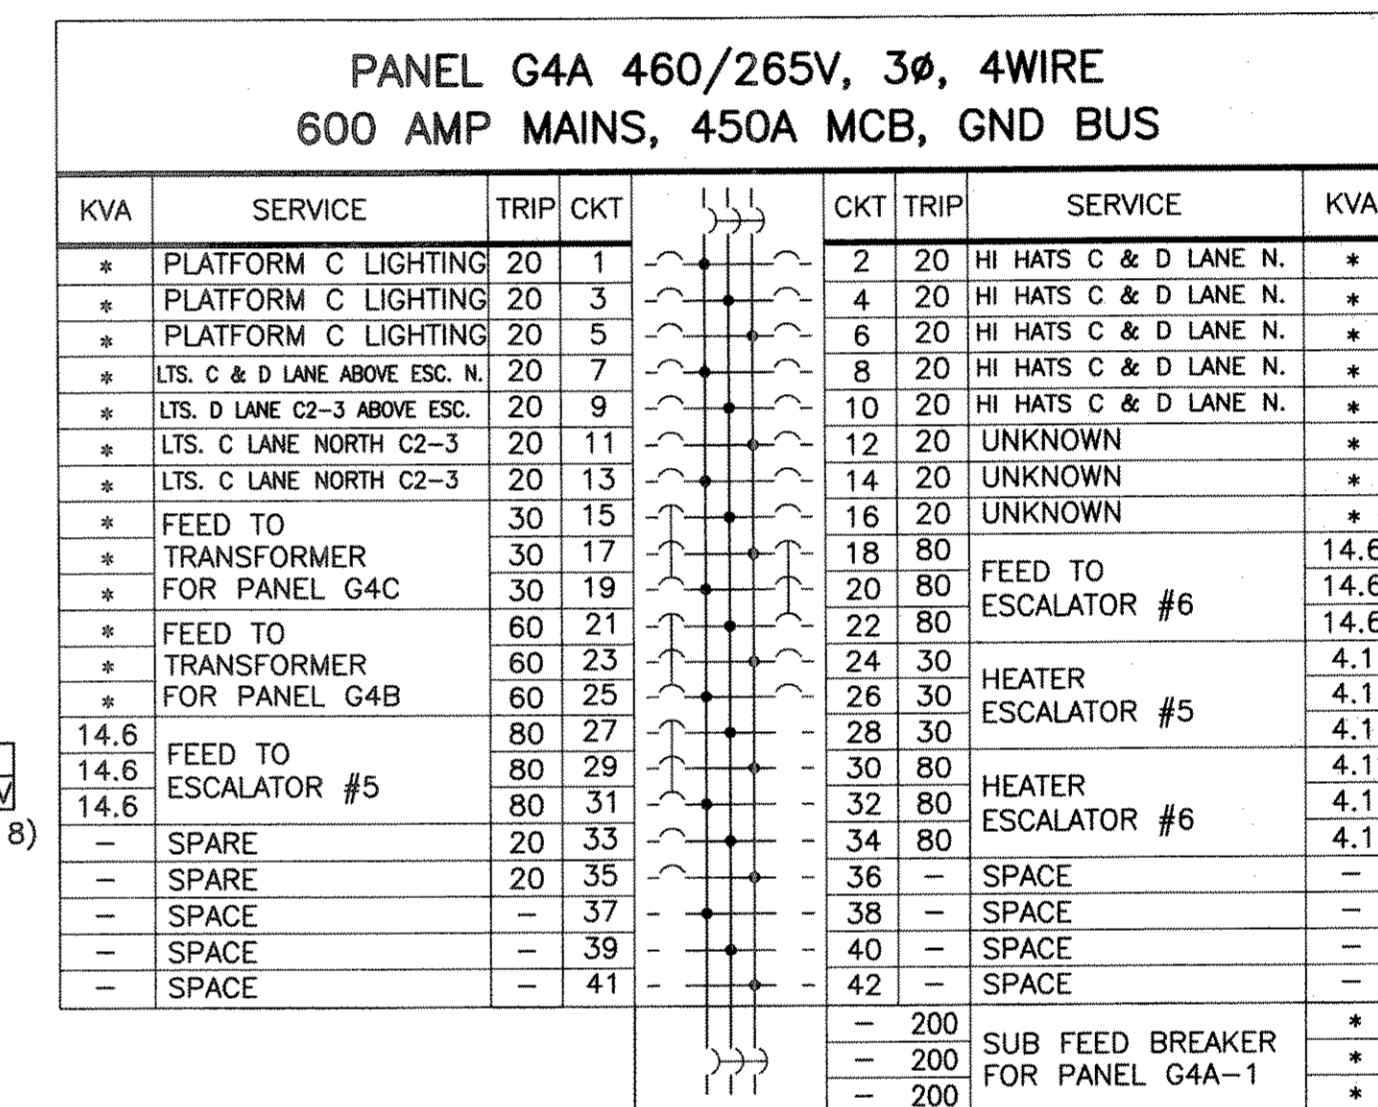
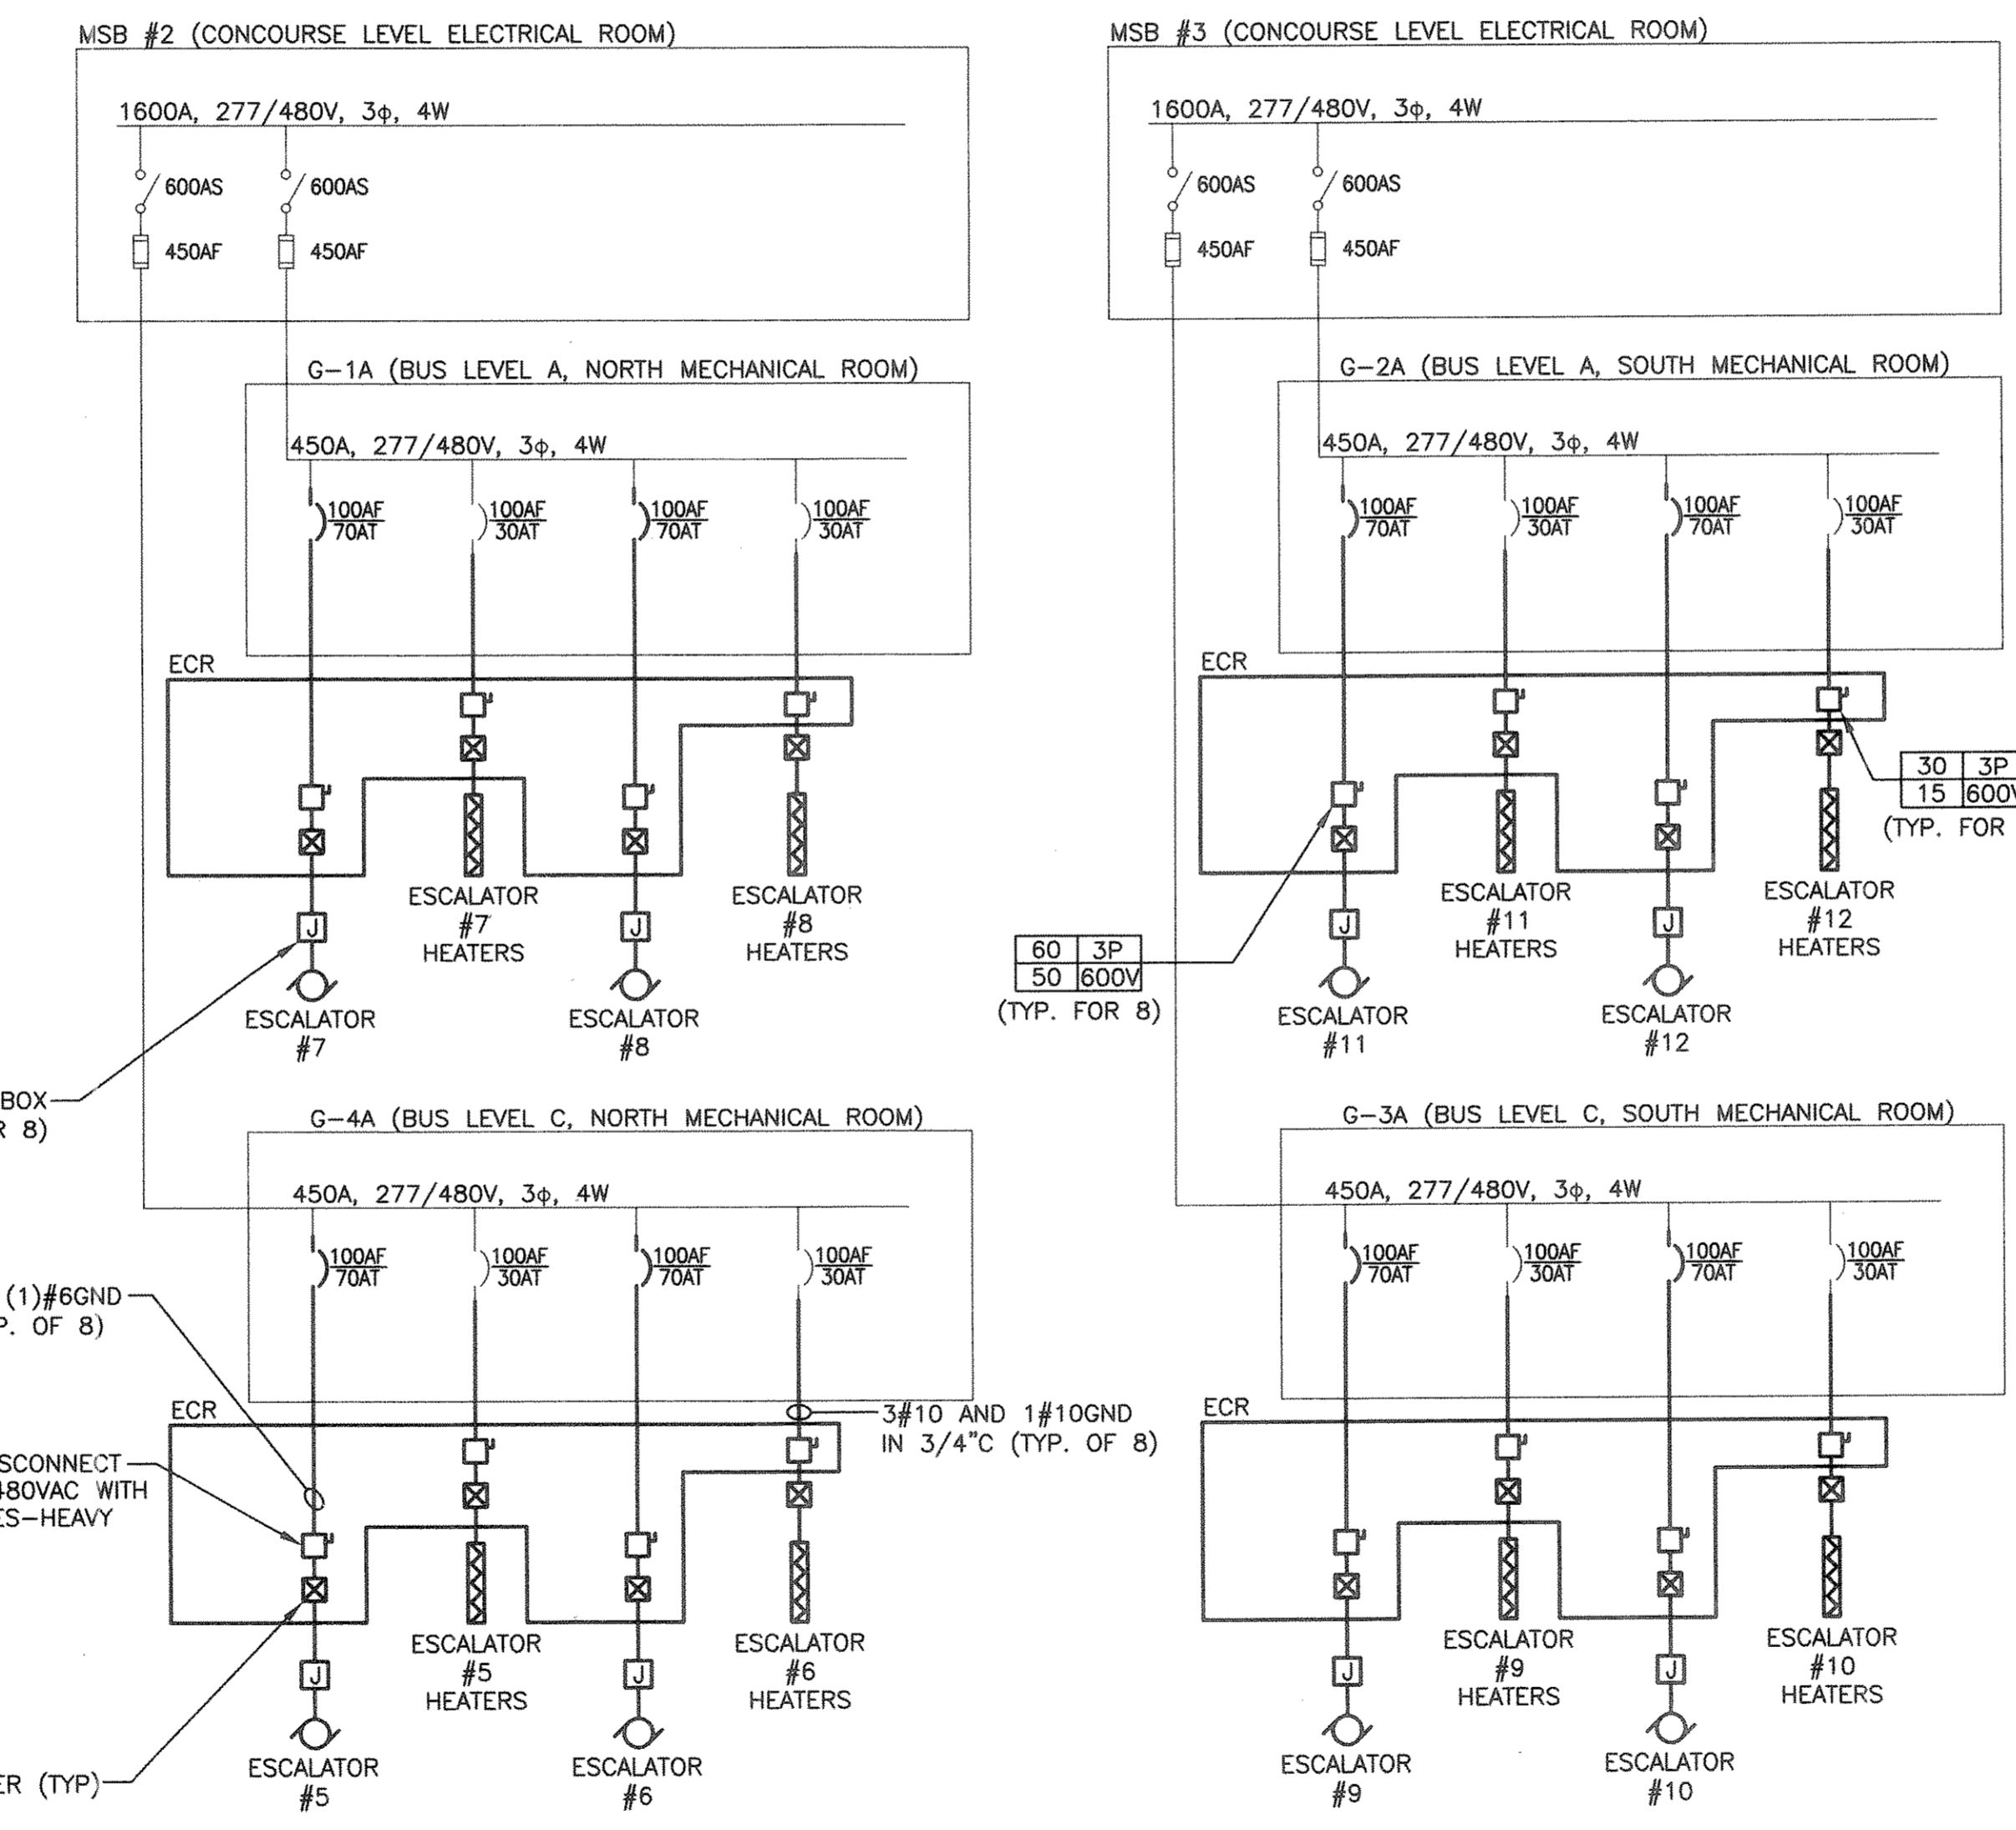
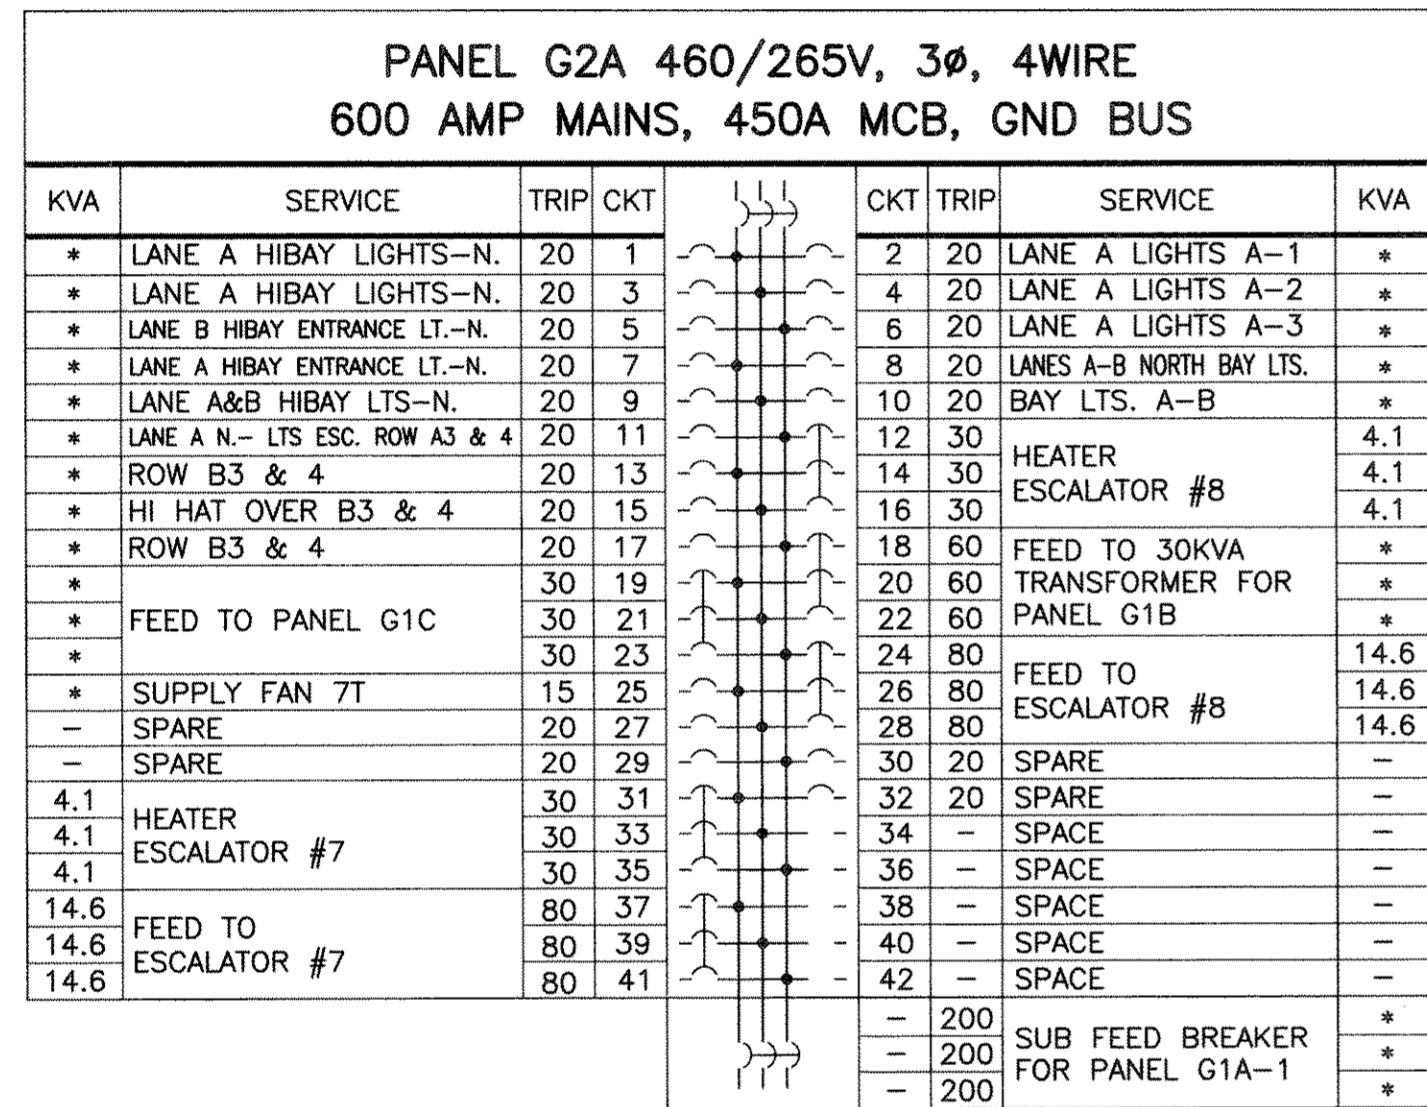
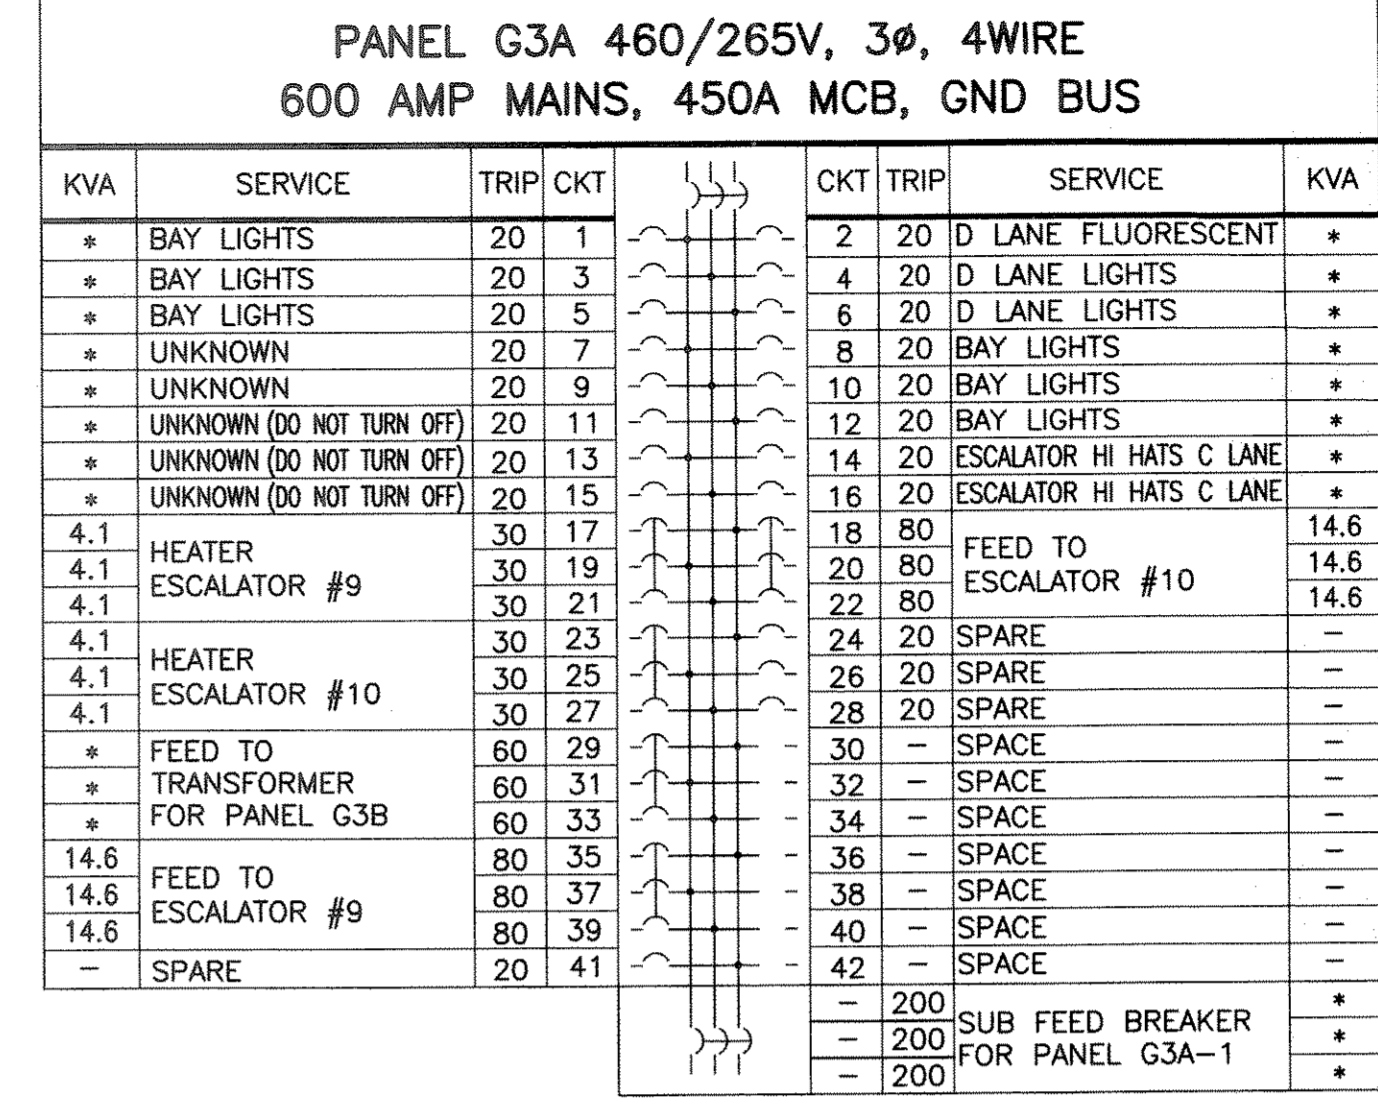


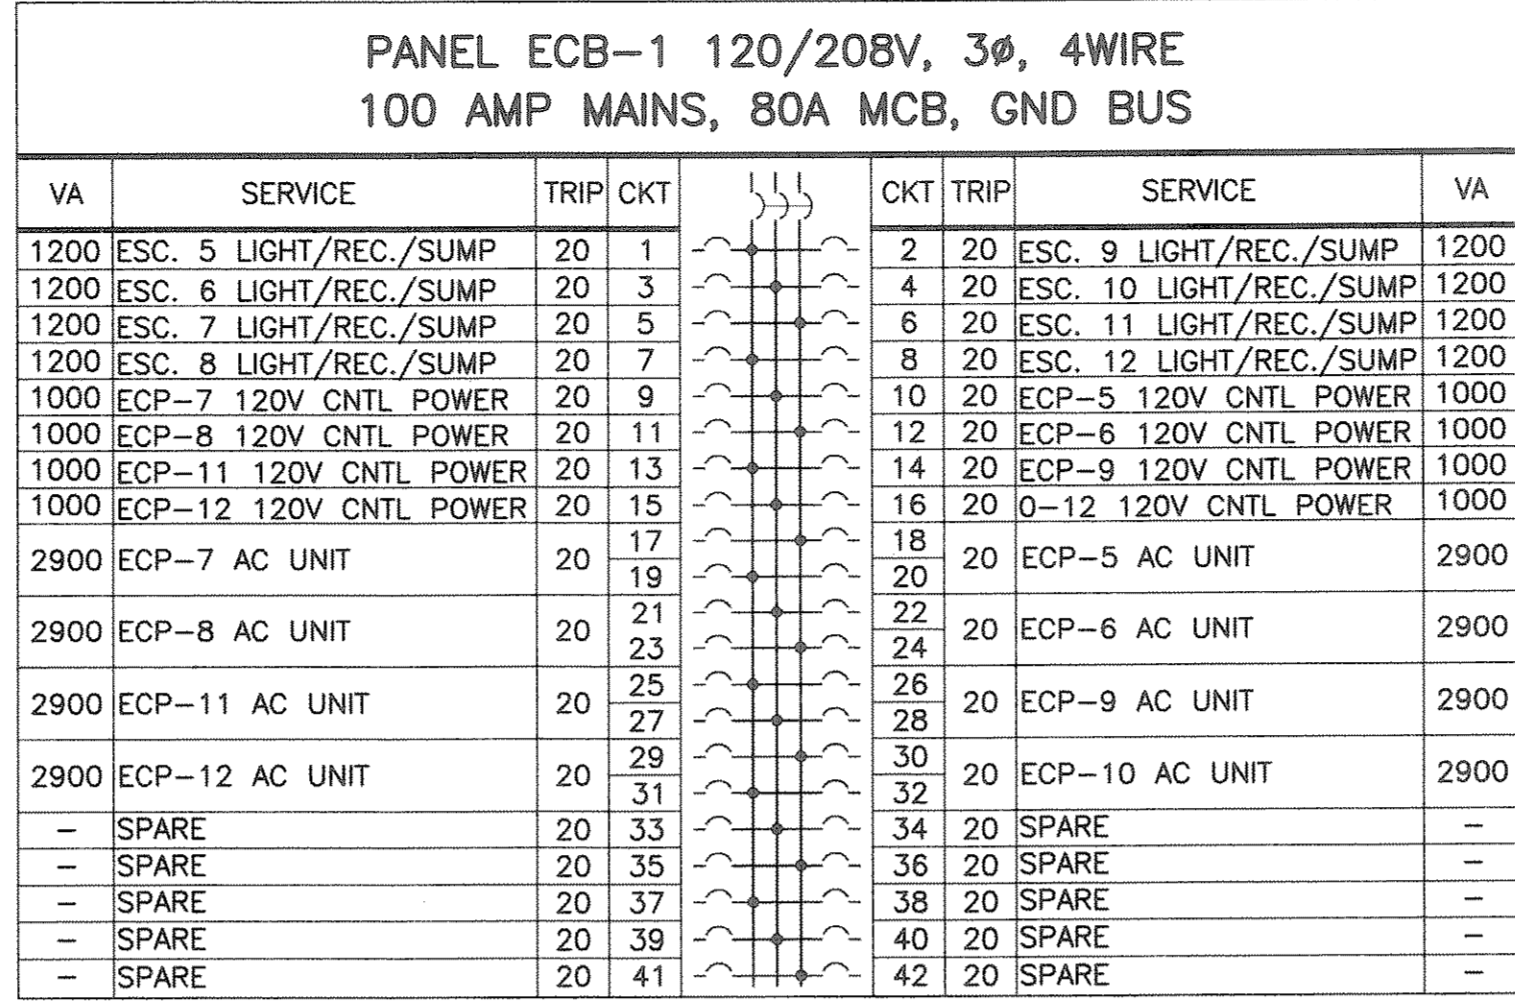

GANNETT FLEMING, P.C.  
ENGINEERS AND ARCHITECTS

GEORGE R. CAMPANELLA  
N.J. Professional Engineer # 24GE04252500

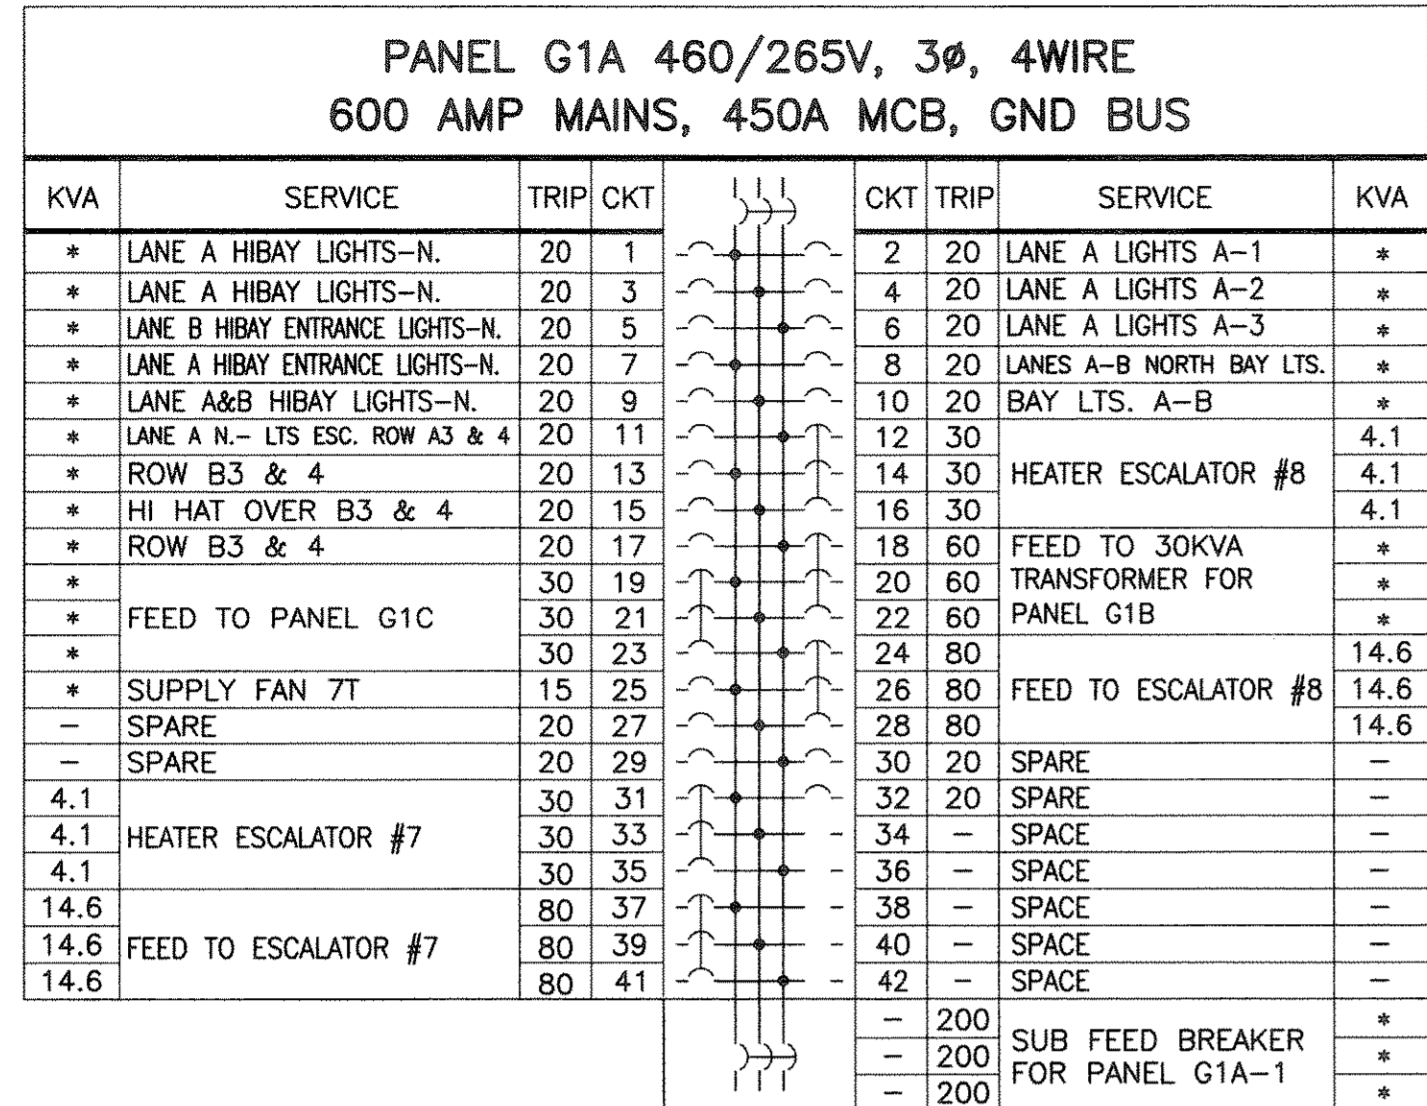

- NOTES:**
- SEE CONTRACT DRAWINGS E004 AND E005 FOR CABLE AND CONDUIT SCHEDULE.
  - SEE CONTRACT DRAWING E011 FOR ESCALATOR MAIN AND AUXILIARY WIRING DIAGRAMS.
  - FOR LEGEND, ABBREVIATIONS, AND GENERAL NOTES SEE CONTRACT DRAWING E001.
  - COORDINATE WITH CONTRACT DRAWING V002, ELECTRICAL INFORMATION.

No.	Date	Revision	Approved

**ENGINEERING DEPARTMENT**

**JOURNAL SQUARE TRANSPORTATION CENTER**

**ELECTRICAL**  
Title  
**BUS TERMINAL ESCALATOR REPLACEMENT**  
**POWER SINGLE LINE DIAGRAM**

T.GILLEN A.CONCHADO G.CAMPANELLA  
Designed by Drawn by Checked by

Date 11/17/2008

Contract Number **PAT-214.004**

Drawing Number **E010**  
PID# 07957000

**POWER SINGLE LINE DIAGRAM**  
SCALE: N.T.S.