

95 WASHINGTON STREET, MORRISTOWN, NJ 07960
t. 973.539.5353 f. 973.539.0916

THE WOOLWORTH BUILDING
233 BROADWAY SUITE 2150, NEW YORK, NY 10279
t. 212.982.7960 f. 212.982.8111
www.nkarchitects.com

ALLEN R. KOPELSON, AIA AI 05644
BEN P. LEE, AIA AI 07017
STEPHEN P. ALUOTTO, AIA AI 09289
PAUL J. DRAGO, AIA AI 17503
WALTER J. KNEIS, AIA AI 10867
DANIEL J. TOPPING, AIA AI 16283

THIS DOCUMENT IS THE EXCLUSIVE PROPERTY OF NK ARCHITECTS. THE DOCUMENT AND THE INFORMATION IT CONTAINS MAY NOT BE REPRODUCED OR USED FOR OTHER THAN THE SPECIFIC PROJECT FOR WHICH IT WAS PREPARED WITHOUT THE EXPLICIT CONSENT OF NK ARCHITECTS.





**Microfabrication
Innovation Center**

211 Summit St., New Jersey Institute of Technology,
University Heights, Newark, NJ

MEP ENGINEERS:

**A&J Consulting
Engineering Services, P.C.**
164 Brighton Road, Clifton, NJ 07012
T: 973-777-9596 | F: 973-777-5528
W: anjengineer.com

JITENDRA K. AGARWAL, P.E.
NJ LIC. NO. GE29632

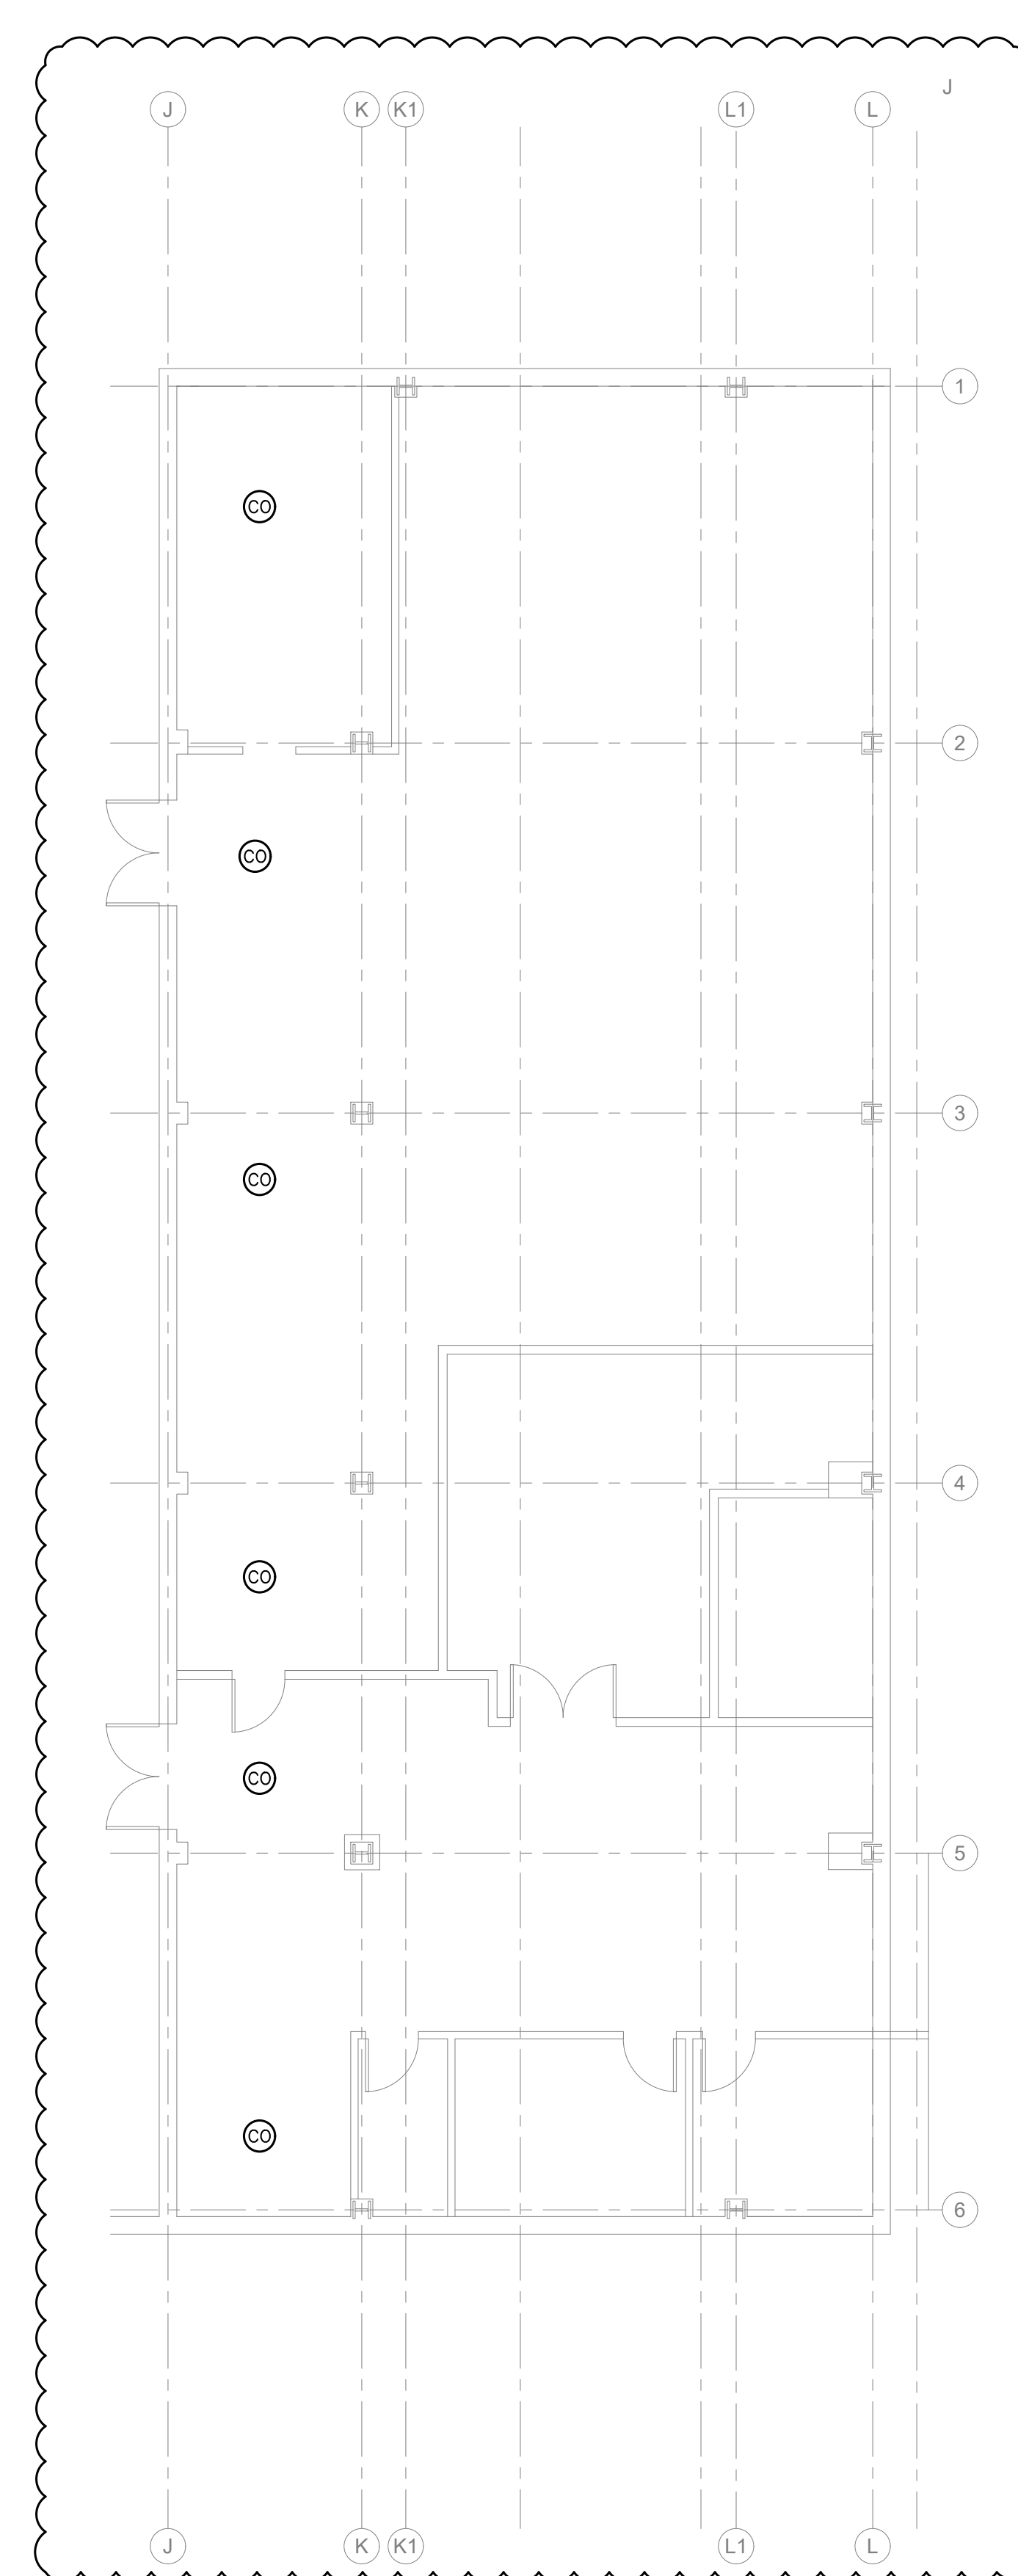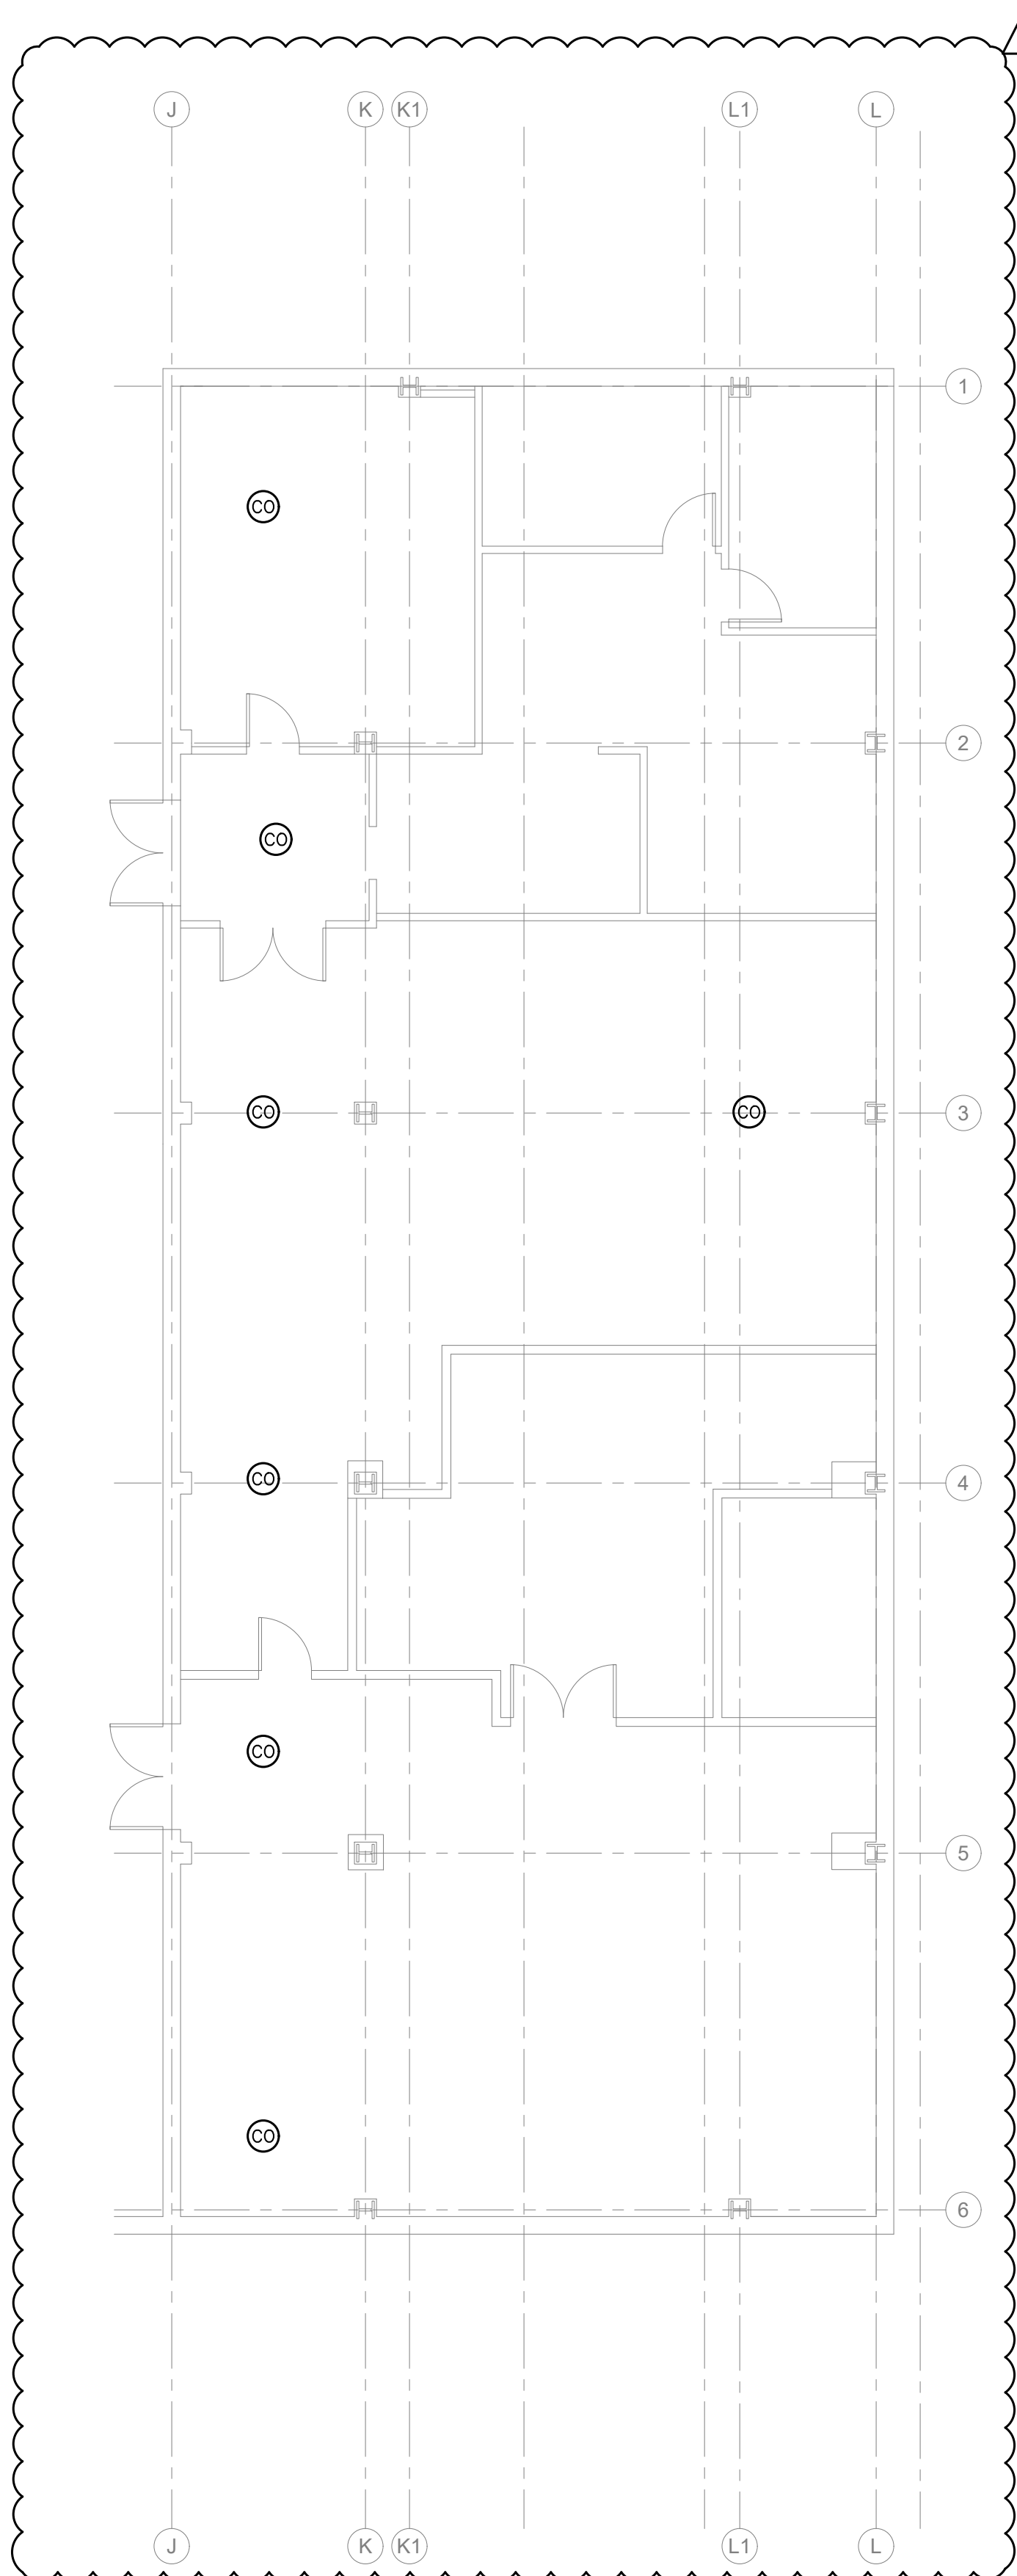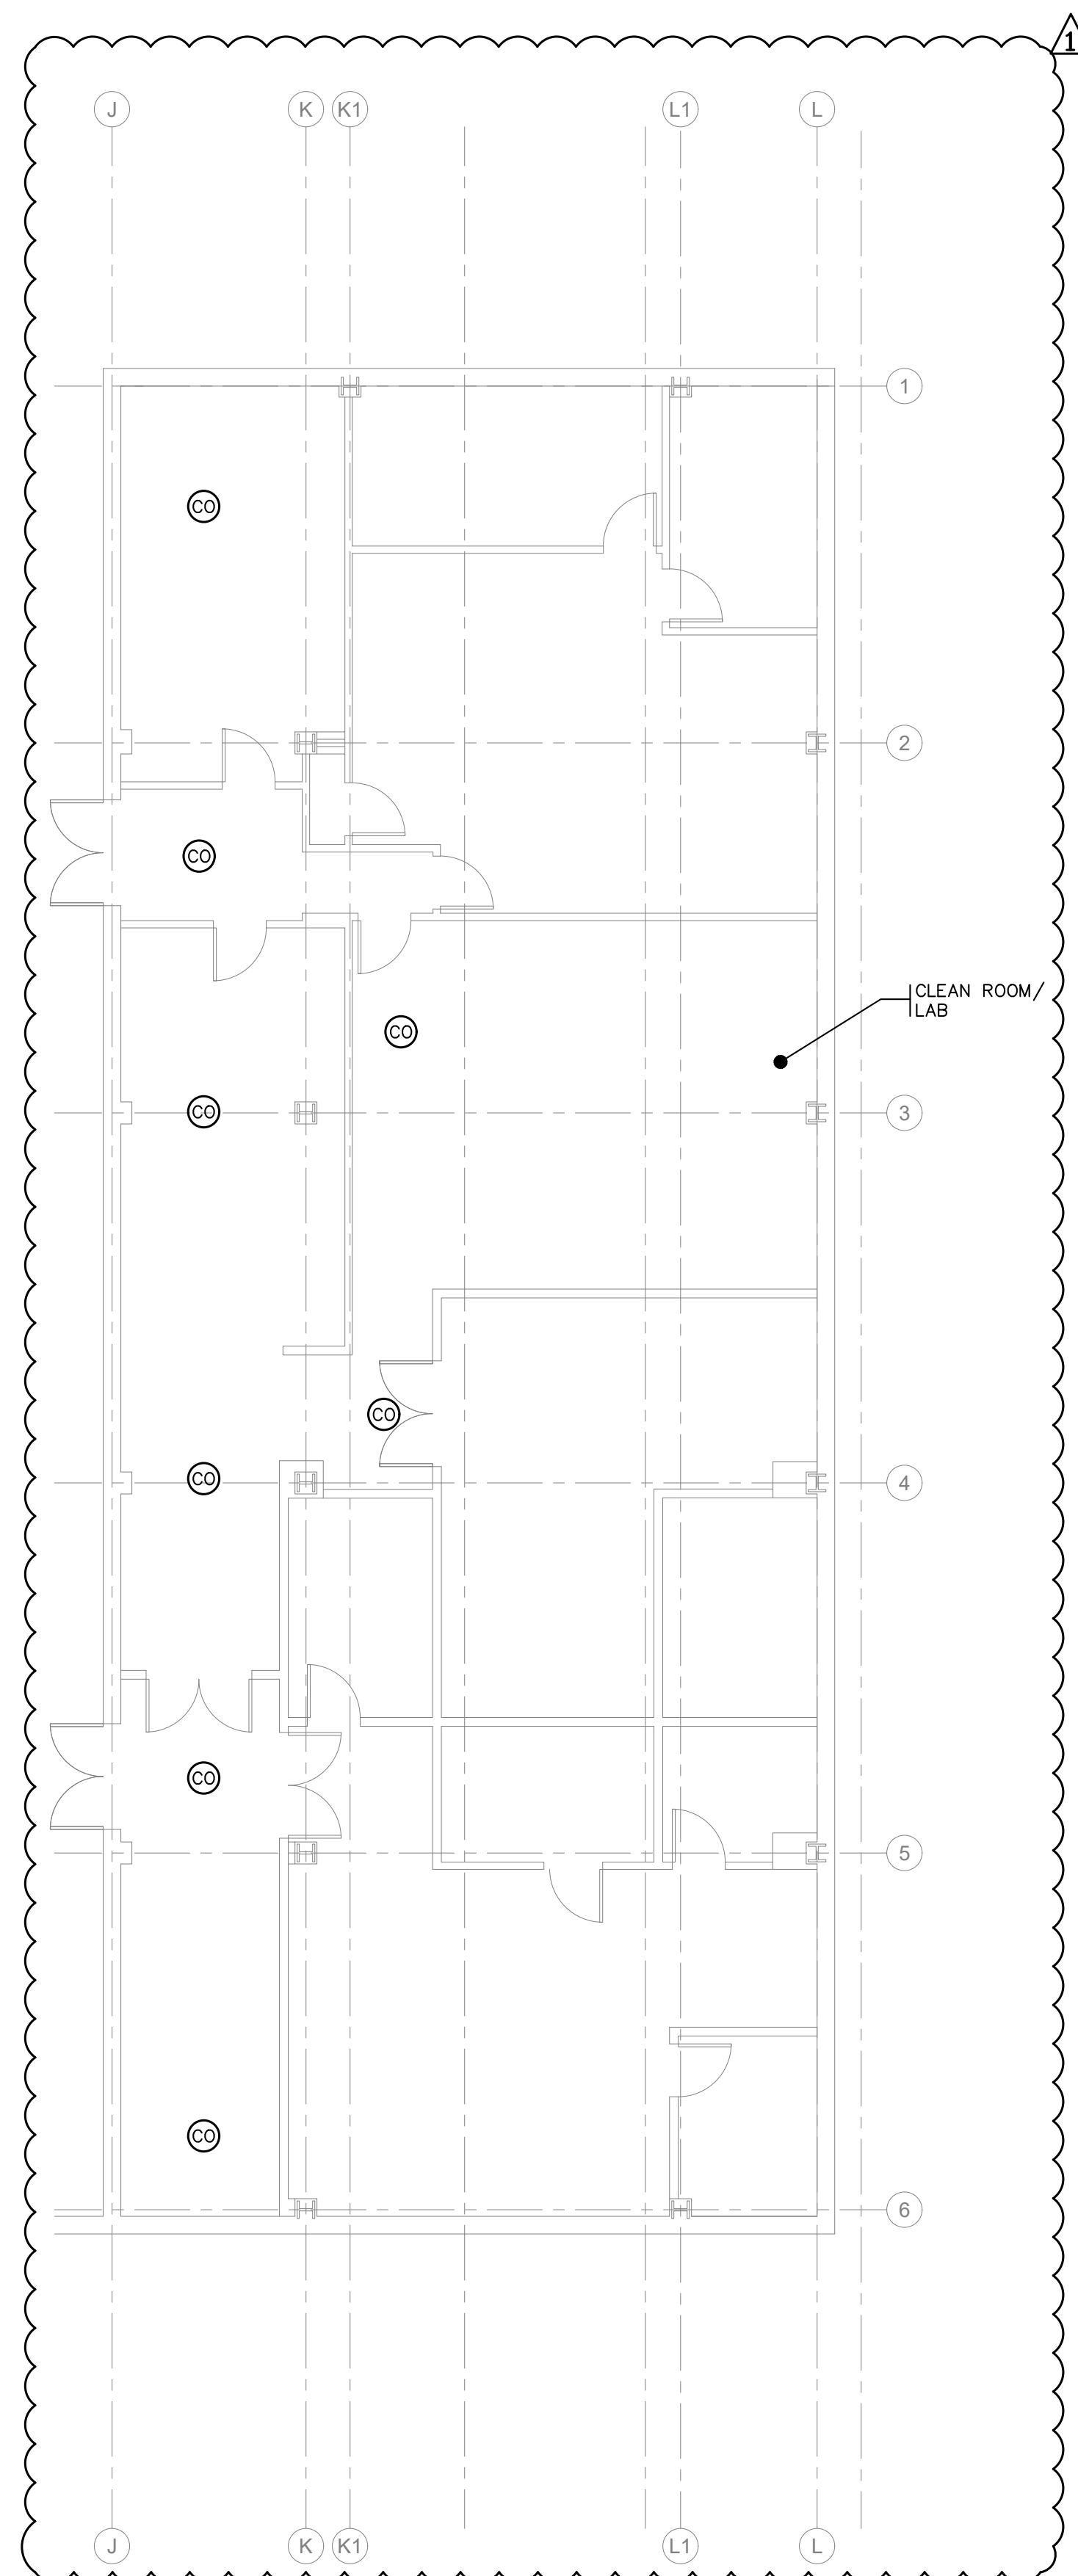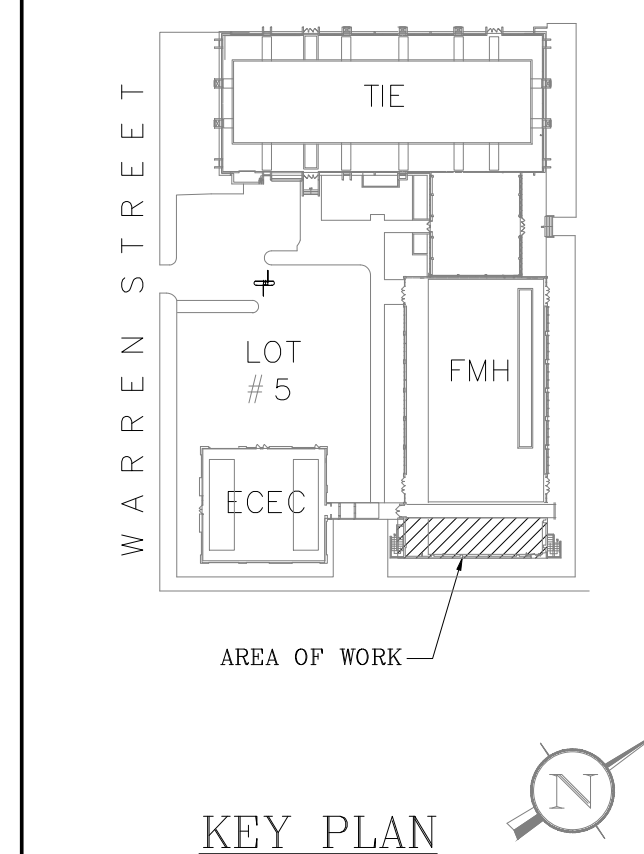

1 SECOND FLOOR PLAN –
FA1.02 CARBON MONOXIDE SYSTEM NEW WORK
1/8" = 1'-0"

2 THIRD FLOOR PLAN –
FA1.02 CARBON MONOXIDE SYSTEM NEW WORK
1/8" = 1'-0"

3 FOURTH FLOOR PLAN –
FA1.02 CARBON MONOXIDE SYSTEM NEW WORK
1/8" = 1'-0"

GENERAL NOTES:
1. REFER TO FA0.01 FOR ABBREVIATIONS, SYMBOLS AND NOTES.

AS-BUILT
THE INFORMATION IN THIS DRAWING IS BASED ON THE CONTRACT DRAWINGS AND CONTRACTOR SHOP DRAWING. THE ENGINEER ASSUMES NO RESPONSIBILITY FOR ITS ACCURACY OTHER THAN CONFORMANCE WITH THE DESIGN CONCEPT.

RESPONSE TO RF# 77			08/19/19
1	AS BUILT	DESCRIPTION	DATE
DRAWING TITLE			

**SECOND, THIRD AND
FOURTH FLOOR PLANS
- NEW FIRE ALARM
WORK**

DATE
01/25/2019
SCALE
AS NOTED
DRAWN
PR/WS
CHECKED
GR
DRAWING NUMBER

FA1.02

NK PROJECT NUMBER: 2144.200