

**GENERAL NOTES**

1. PROVIDE UL LISTED FIRE STOPPING AT ALL PIPING PENETRATION THROUGH CORRIDOR WALLS.

NJ Certificate of Authorization	
Eng'r. No.	24627837500
Arch. No.	21AC00912400
Date	01/15/2018
Checked	
Drawn	

**KENNETH H. KARLE, R.A.**  
REGISTERED ARCHITECT  
License No. NJ21A00890600


**Revisions:**

**LAN ASSOCIATES**  
 engineering • planning • architecture • surveying  
 445 GODWIN AVENUE, MIDLAND PARK, N.J. 07432 (201)447-6400


**HVAC 1ST & 2ND FLR PIPING PLANS**  
 ADDITION TO WOODBRIDGE MIDDLE SCHOOL  
 WOODBRIDGE BOE  
 525 BARRON AVENUE  
 WOODBRIDGE, NJ 07095

Job No. 2.20211.07  
 File No. -


**H2.05**

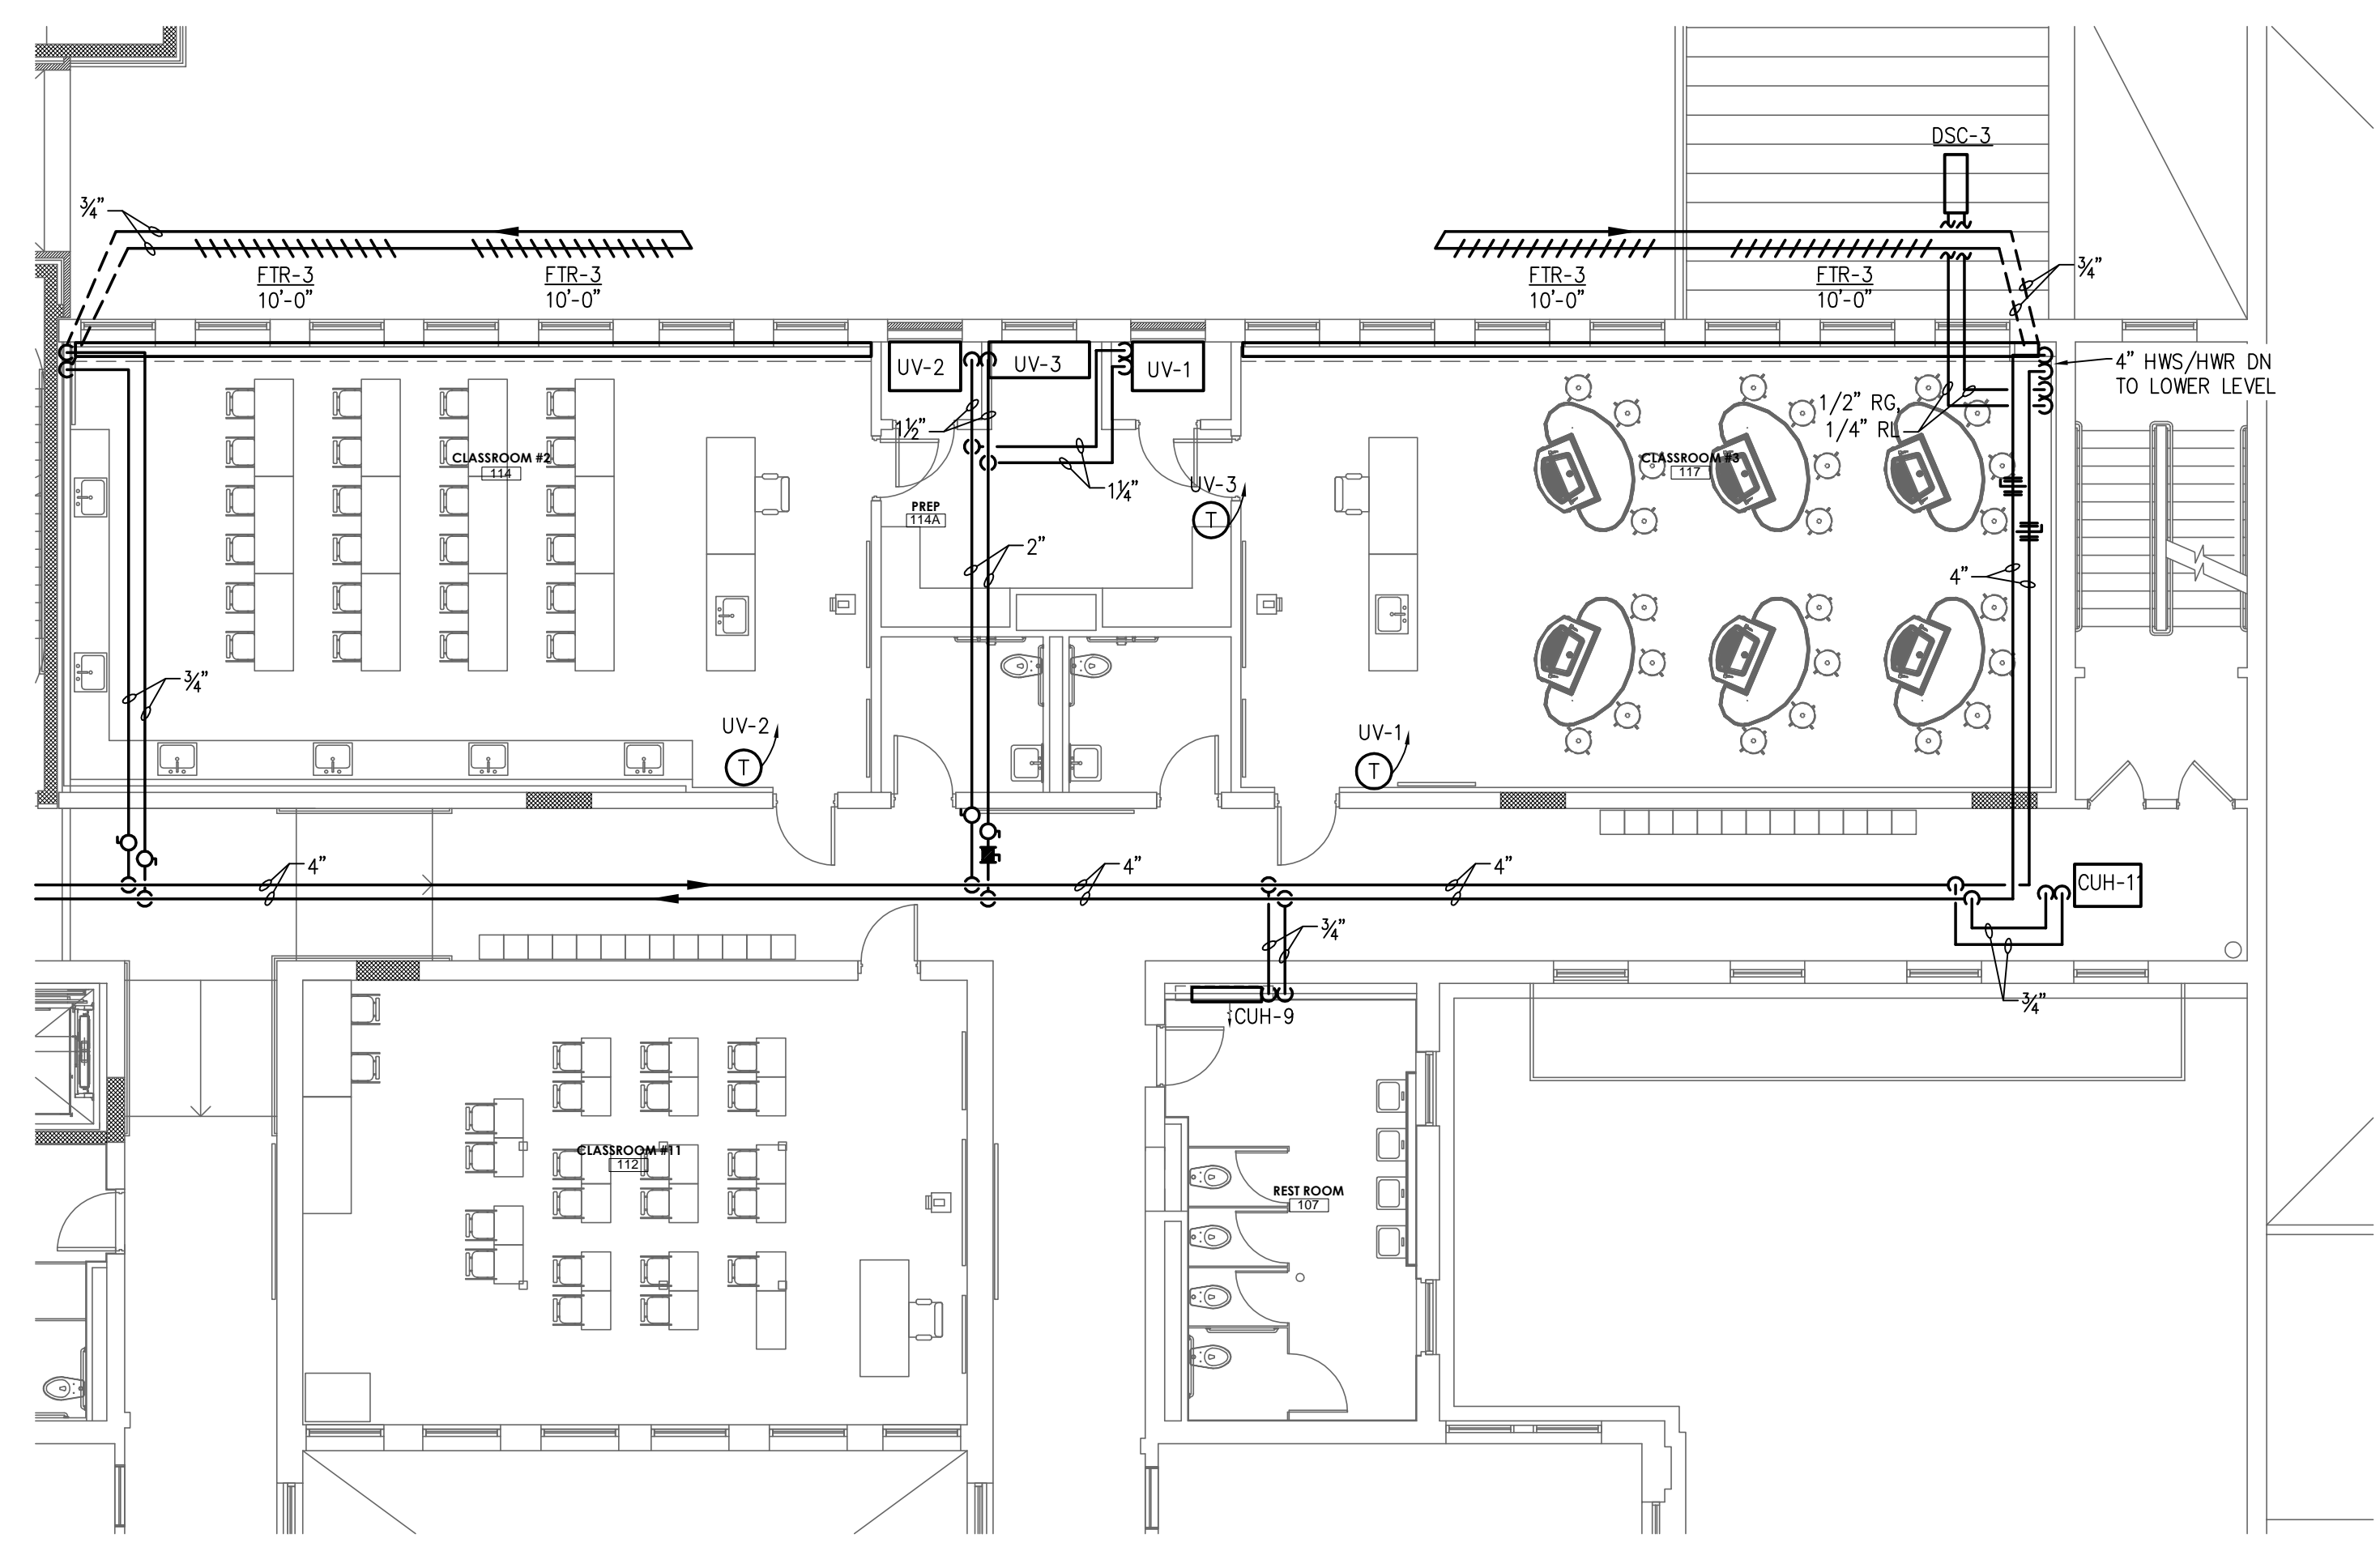

**1 HVAC FIRST FLOOR PIPING PLAN**  
 H2.05 1/8" = 1'-0"

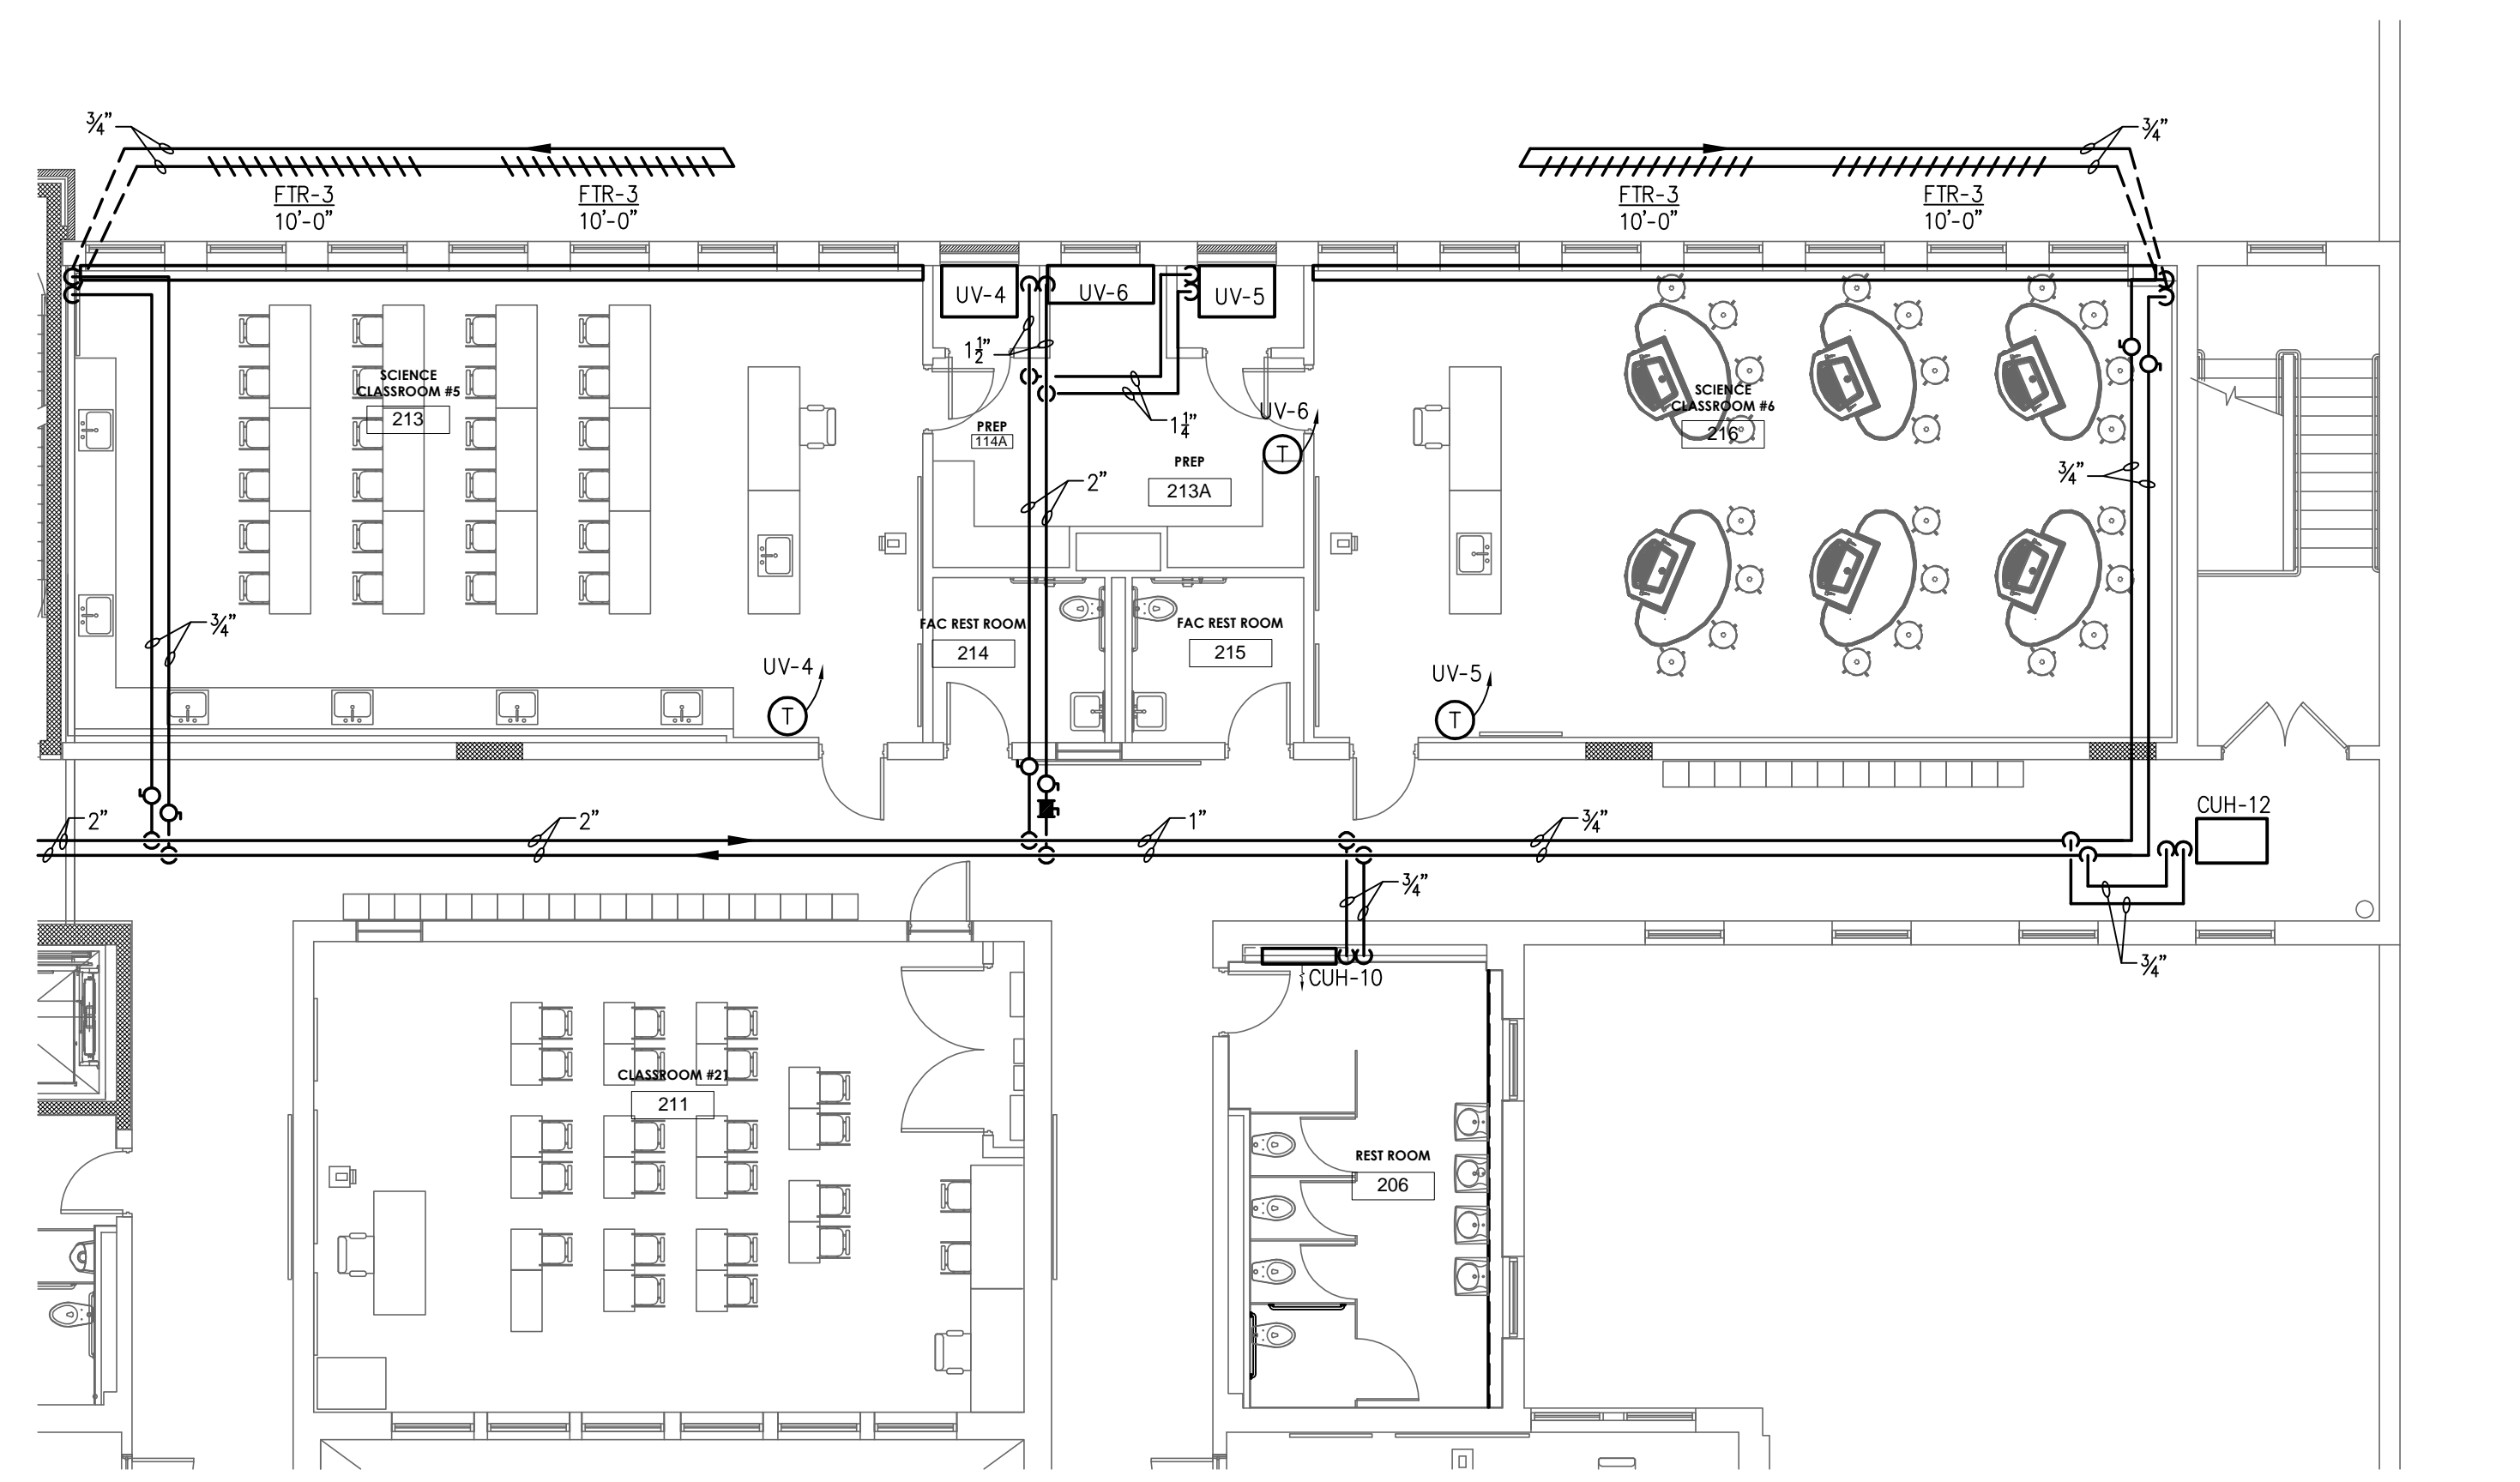

**2 HVAC SECOND FLOOR PIPING PLAN**  
 H2.05 1/8" = 1'-0"

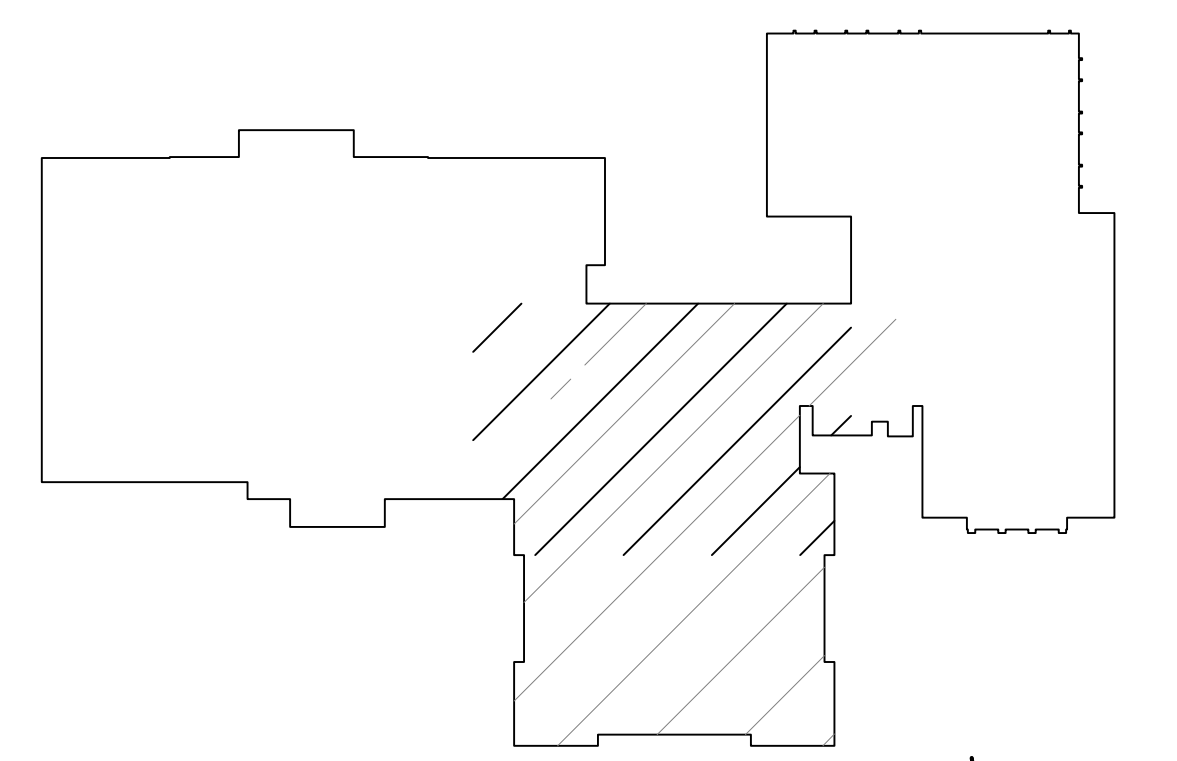

**KEY PLAN**  
 N.T.S.