


ORIGINAL
IF IT IS RED IT IS AN ORIGINAL

P:\1050-1090\108813 UC College 1st Fl. Lessner Building DOCUMENTS\6.4 Dwg\6.4_Ceiling\A111.dwg, A111, 10/31/2016 4:52:26 PM

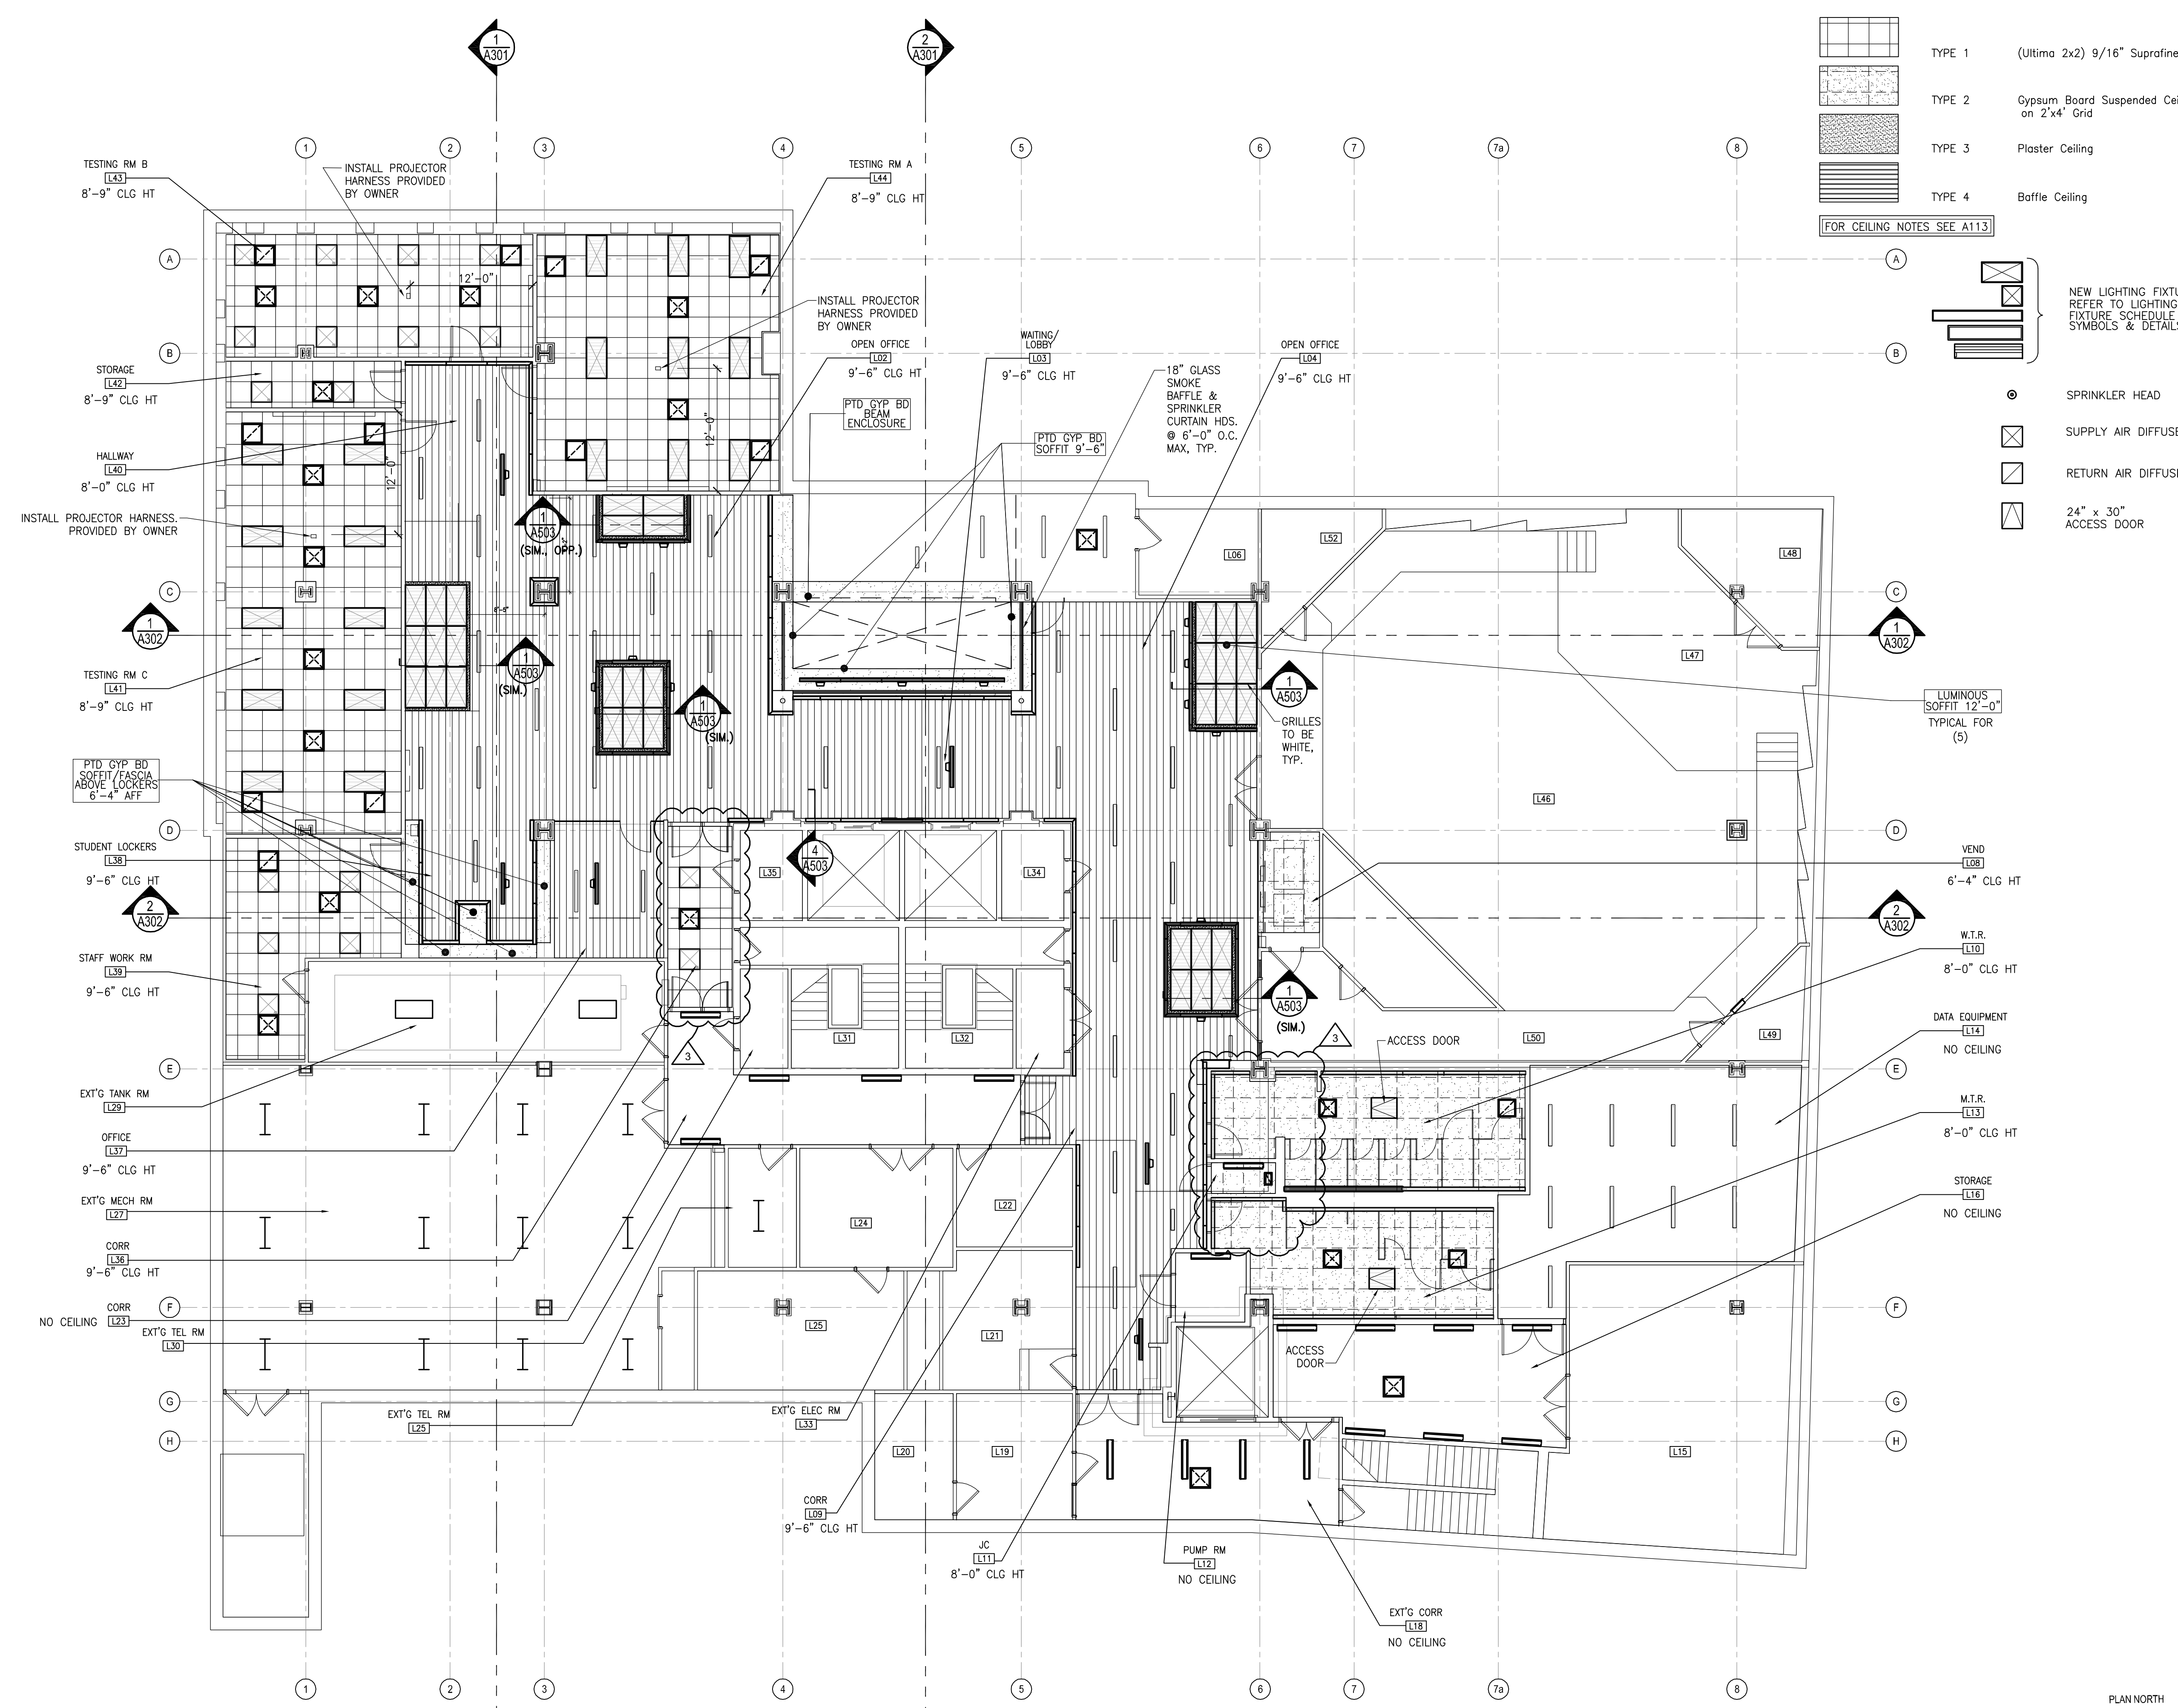

LEGEND

	TYPE 1	(Ultima 2x2) 9/16" Suprafine Grid
	TYPE 2	Cypsum Board Suspended Ceiling on 2'x4' Grid
	TYPE 3	Plaster Ceiling
	TYPE 4	Baffle Ceiling

FOR CEILING NOTES SEE A113

- NEW LIGHTING FIXTURES. REFER TO LIGHTING FIXTURE SCHEDULE FOR SYMBOLS & DETAILS.
- SPRINKLER HEAD
 - SUPPLY AIR DIFFUSER
 - RETURN AIR DIFFUSER
 - 24" x 30" ACCESS DOOR

N.J. A105415 N.Y. 11339

CT. 09009 PA. B 6580

Noel S. Musial, A.I.A.

The Drawings, Specifications and other documents prepared by The Architect for this project are instruments of the Architect's service for use solely with respect to this project and the Architect shall be deemed the author of statutory and other reserved rights, including copyright. The owner shall be permitted to retain copies, including reproducible copies, of the Architect's drawings, Specifications or other documents shall not be used by the Owner or others on other projects, for additions to this Project or for completion of this Project by others, unless the Architect agrees in writing and with appropriate compensation to the Architect.

Submission or distribution of documents to meet official regulatory requirements or for similar purposes in connection with the Project is not to be construed as publication in derogation of the Architect's reserved rights.

Each CONTRACTOR SHALL THOROUGHLY EXAMINE AND BECOME FAMILIAR WITH ALL CONTRACT DOCUMENTS FOR THE PROJECT AND NOT LIMIT THEIR WORK TO DRAWINGS REFERENCED FOR INDIVIDUAL TRADES.

© Copyright 2016
BUSINESS PROPRIETARY INFORMATION

Union County College

LESSNER FIRST FLOOR ADDITION & FIRST FLOOR & LOWER LEVEL REHABILITATION

Lessner Building
Elizabeth Campus

12 West Jersey Street
Elizabeth, NJ 07202

THE MUSIAL GROUP ARCHITECTURE

191 Mill Lane
Mountainside, NJ 07092
t. 908.232.2860
f. 908.232.2845
e. studio@themusialgroup.com

March 2016

Revision Number	Revision Description	Revision Date
1	ADDENDUM # 1	04/05/2016
2	ADDENDUM # 2	04/11/2016
3	REVISION # 3	10/31/2016

Scale: 1/8" = 1'-0"
Drawn by: AMB
Checked by:

108813

LOWER LEVEL REFLECTED CEILING PLAN

A111

1
A111 LOWER LEVEL REFLECTED CEILING PLAN
SCALE: 1/8" = 1'-0"

